


PLEASE NOTE

FOR CONSTRUCTION PURPOSES USE ONLY FIGURED DIMENSIONS. THIS DRAWING MUST ALWAYS BE READ IN CONJUNCTION WITH ALL RELEVANT PROJECT DETAILS. ALL DIMENSIONS MUST BE CHECKED ON SITE PRIOR TO COMMENCEMENT. PLEASE REPORT ANY DISCREPANCY TO THE ARCHITECT OR CONTRACT ADMINISTRATOR

© COPYRIGHT XTERIORSCAPES 2025

Revisions
AO 02/04/25

NTS
NTS

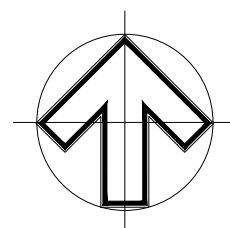



 
 
 
 
Drawing Street Tree & Lighting Plan		Project Date Jun 2021	
Project/Client Riverstone Subdivision Yoursection Ltd		Scale @ A3 NTS	
Job reference Drawing number 20082 ST LT-001		Revision AO	Purpose of Issue Approval



441 Papanui Road, PO Box 36-511
Christchurch 8146

m: 021 433 418 t: 03 421 8460
hayden@xteriorscapes.nz
www.xteriorscapes.nz

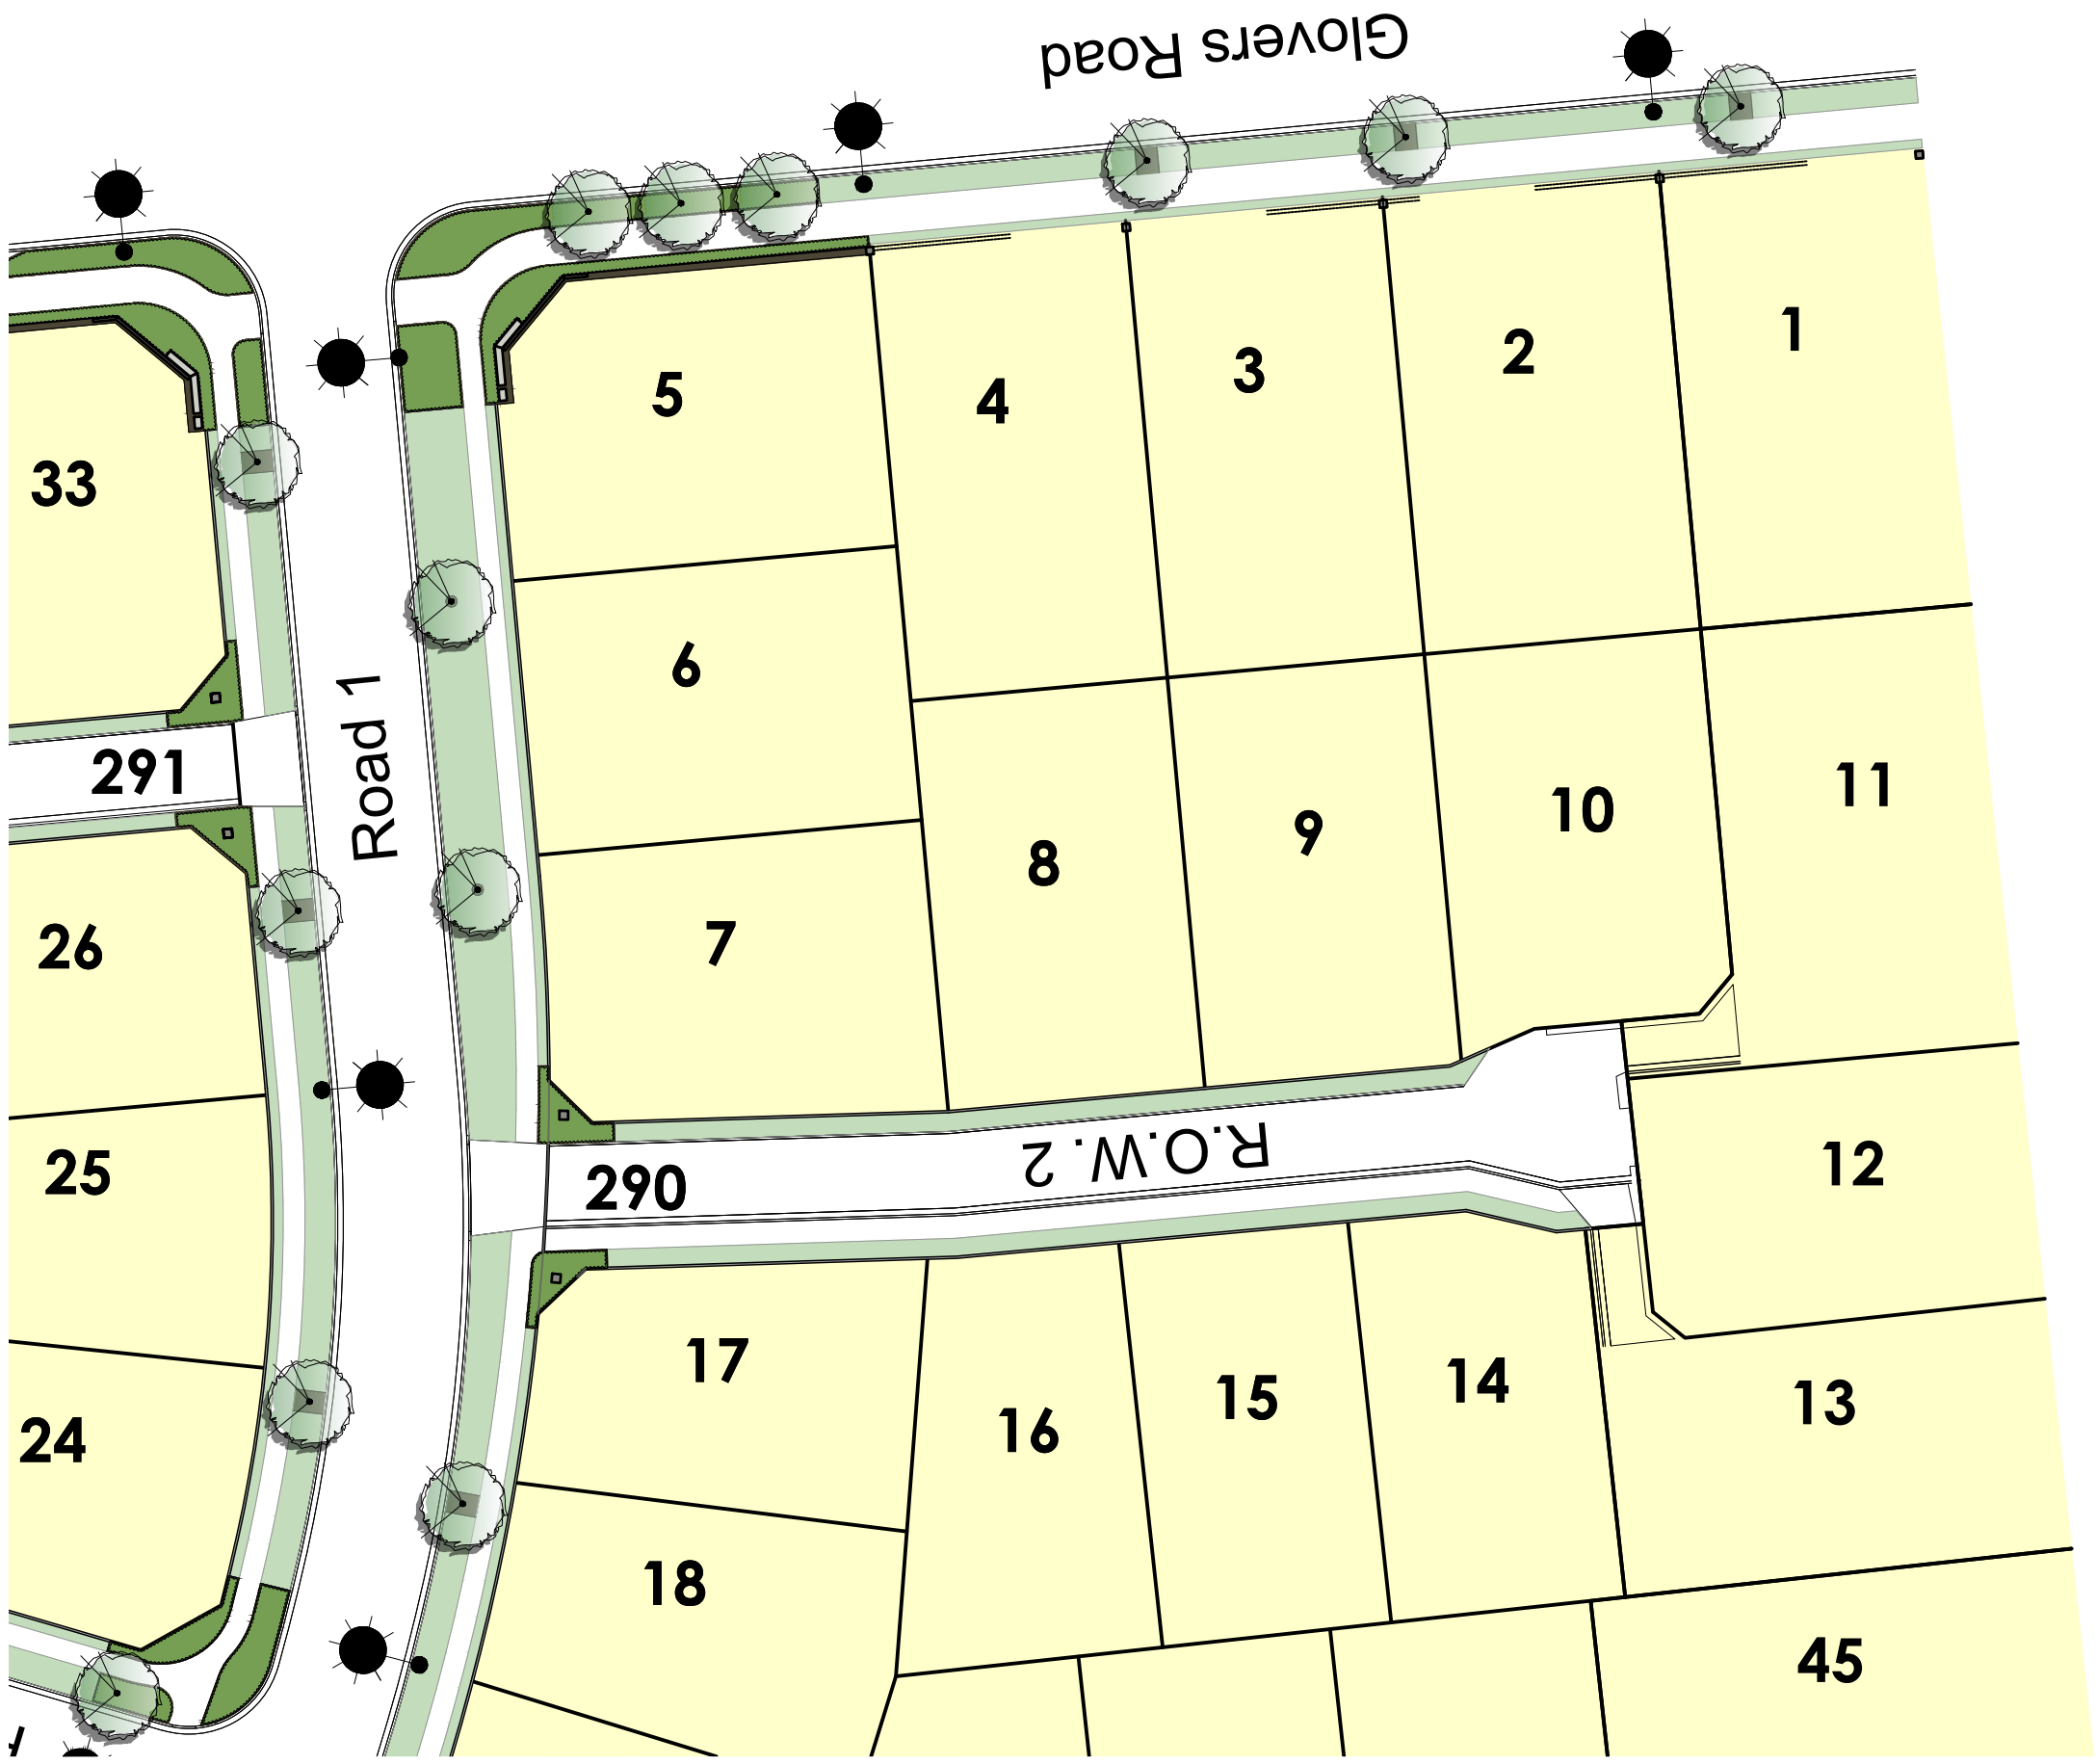


- Key:
-  Proposed Tree
 -  Garden Bed
 -  Grass
 -  Proposed Lot
 -  Street light

PLEASE NOTE

FOR CONSTRUCTION PURPOSES USE ONLY FIGURED DIMENSIONS. THIS DRAWING MUST ALWAYS BE READ IN CONJUNCTION WITH ALL RELEVANT PROJECT DETAILS. ALL DIMENSIONS MUST BE CHECKED ON SITE PRIOR TO COMMENCEMENT. PLEASE REPORT ANY DISCREPANCY TO THE ARCHITECT OR CONTRACT ADMINISTRATOR

© COPYRIGHT XTERIORSCAPES 2025

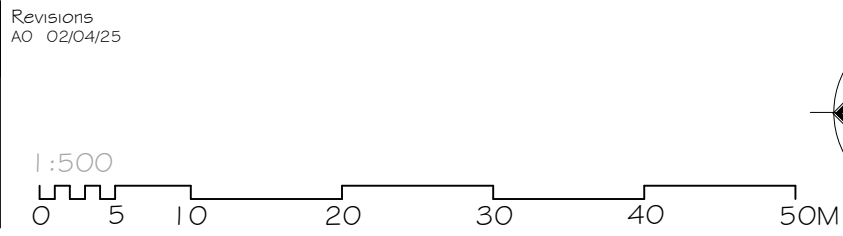

Drawing Street Tree and Lighting Plan		Project Date Jun 2021	
Project/Client Riverstone Subdivision Yoursection Ltd		Scale @ A3 1:500	
Job reference Drawing number 20082 ST LT-002		Revision AO	Purpose of Issue Approval




xteriorscapes
LANDSCAPE ARCHITECTS

441 Papanui Road, PO Box 36-511
Christchurch 8146

m: 021 433 418 t: 03 421 8460
hayden@xteriorscapes.nz
www.xteriorscapes.nz


- Key:
-  Proposed Tree
 -  Garden Bed
 -  Grass
 -  Proposed Lot
 -  Street light

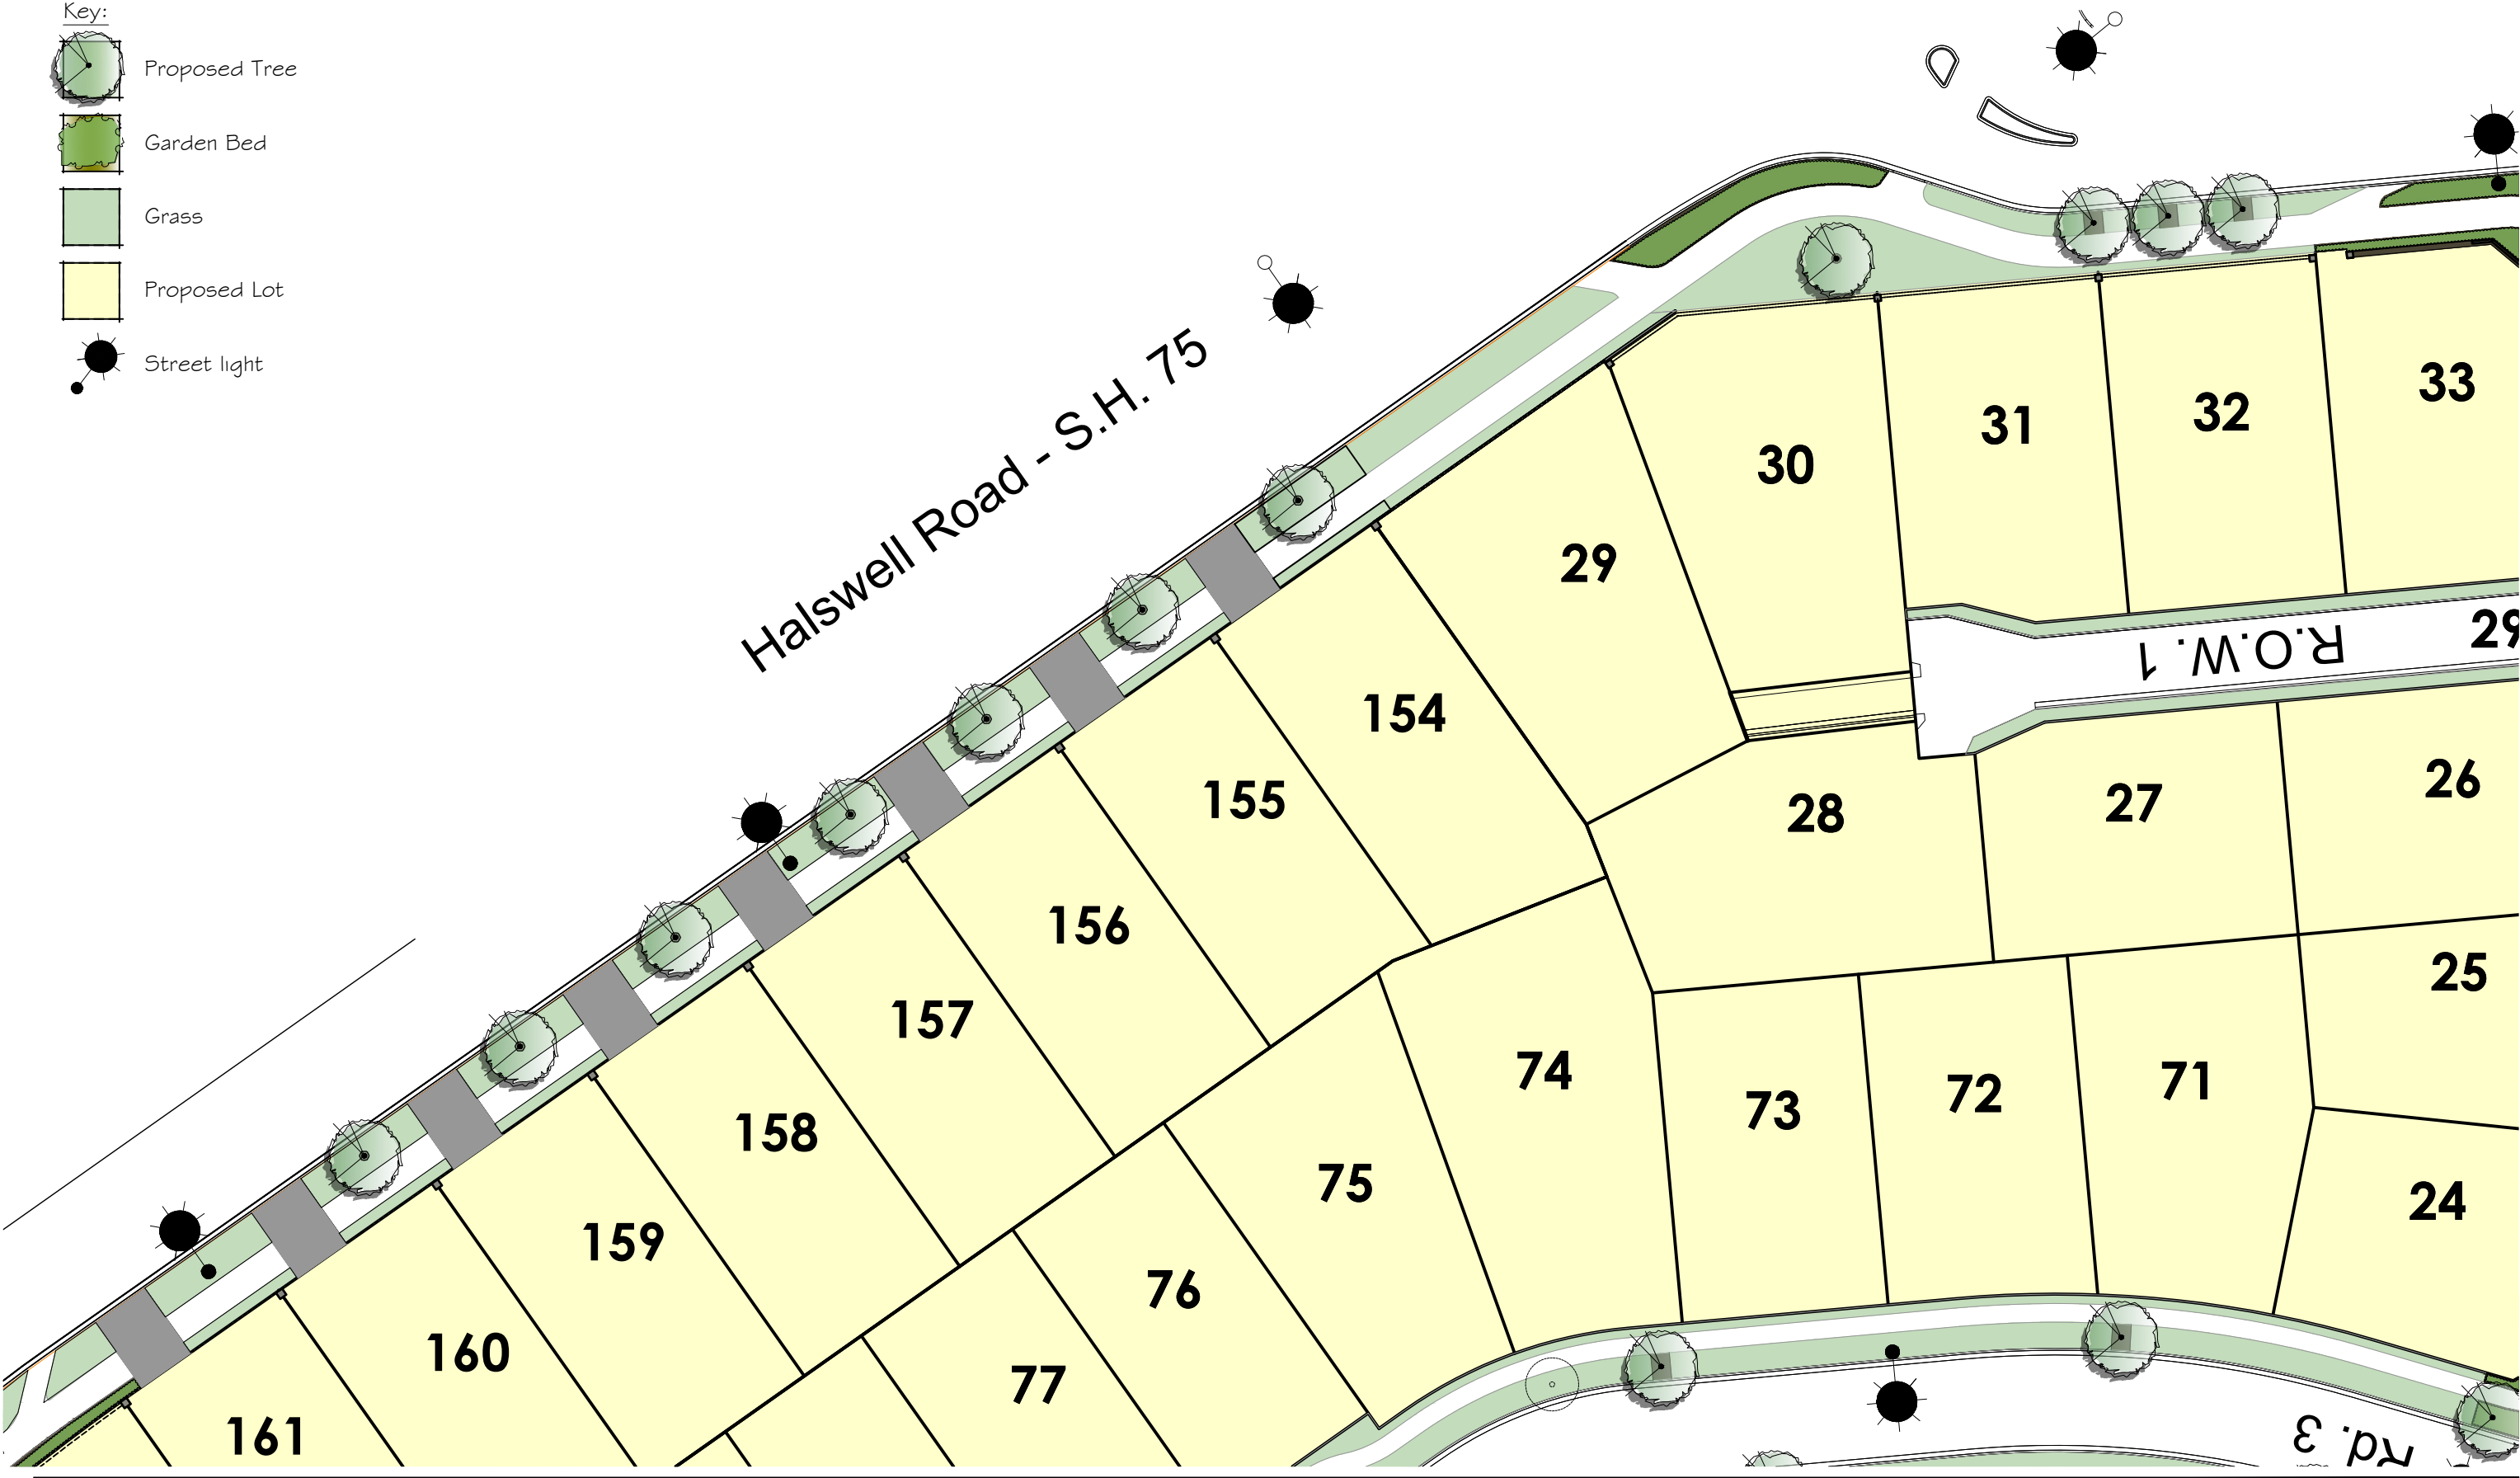

PLEASE NOTE

FOR CONSTRUCTION PURPOSES USE ONLY FIGURED DIMENSIONS. THIS DRAWING MUST ALWAYS BE READ IN CONJUNCTION WITH ALL RELEVANT PROJECT DETAILS. ALL DIMENSIONS MUST BE CHECKED ON SITE PRIOR TO COMMENCEMENT. PLEASE REPORT ANY DISCREPANCY TO THE ARCHITECT OR CONTRACT ADMINISTRATOR

© COPYRIGHT XTERIORSCAPES 2025

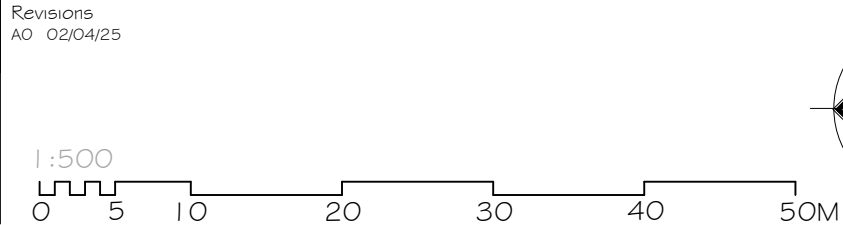


Drawing Street Tree and Lighting Plan		Project Date Jun 2021	
Project/Client Riverstone Subdivision Yoursection Ltd		Scale @ A3 1:500	
Job reference Drawing number 20082 ST LT-003		Revision AO	Purpose of Issue Approval



xteriorscapes
LANDSCAPE ARCHITECTS

441 Papanui Road, PO Box 36-511
Christchurch 8146

m: 021 433 418 t: 03 421 8460
hayden@xteriorscapes.nz
www.xteriorscapes.nz

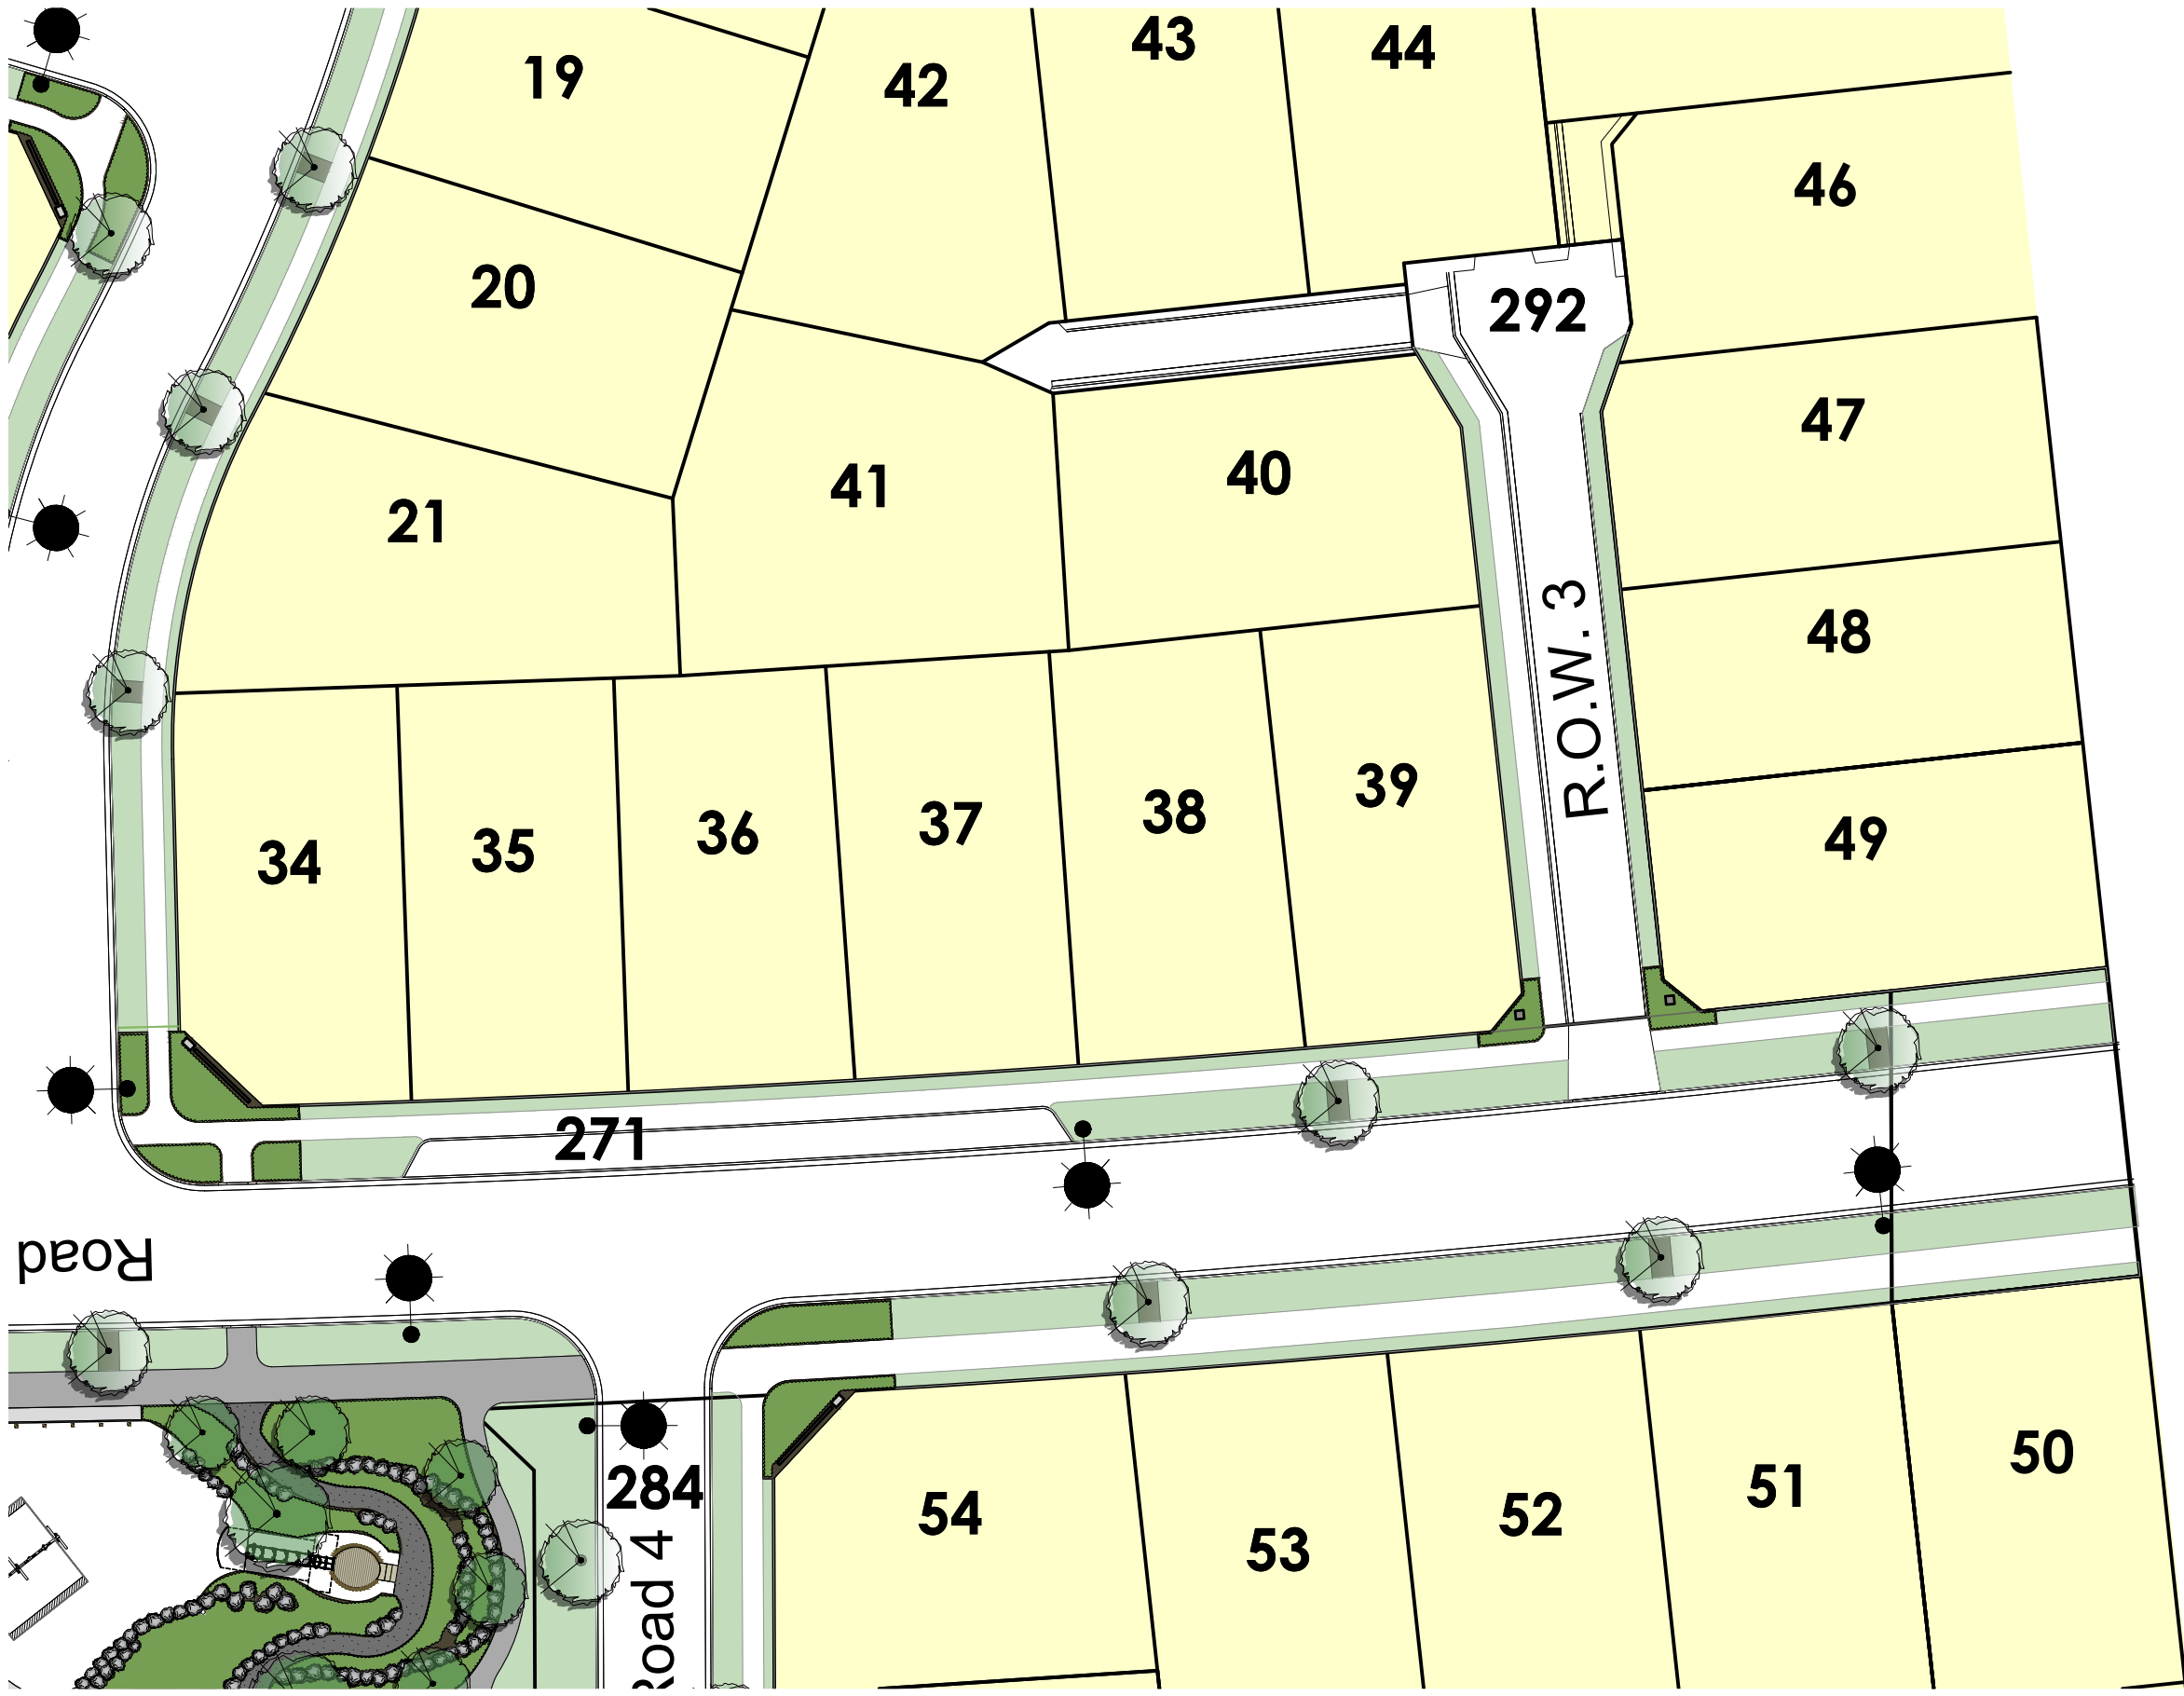

- Key:
- Proposed Tree
 - Garden Bed
 - Grass
 - Proposed Lot
 - Street light


 
PLEASE NOTE

FOR CONSTRUCTION PURPOSES USE ONLY FIGURED DIMENSIONS. THIS DRAWING MUST ALWAYS BE READ IN CONJUNCTION WITH ALL RELEVANT PROJECT DETAILS. ALL DIMENSIONS MUST BE CHECKED ON SITE PRIOR TO COMMENCEMENT. PLEASE REPORT ANY DISCREPANCY TO THE ARCHITECT OR CONTRACT ADMINISTRATOR

© COPYRIGHT XTERIORSCAPES 2025

Revisions
AO 02/04/25

1:500

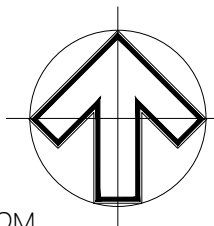

Drawing Street Tree and Lighting Plan		Project Date Jun 2021	
Project/Client Riverstone Subdivision Yoursection Ltd		Scale @ A3 1:500	
Job reference Drawing number 20082 ST LT-004		Revision AO	Purpose of Issue Approval

xteriorscapes
LANDSCAPE ARCHITECTS

441 Papanui Road, PO Box 36-511
Christchurch 8146

m: 021 433 418 t: 03 421 8460
hayden@xteriorscapes.nz
www.xteriorscapes.nz





- Key:
- Proposed Tree
 - Garden Bed
 - Grass
 - Proposed Lot
 - Street light

PLEASE NOTE

FOR CONSTRUCTION PURPOSES USE ONLY FIGURED DIMENSIONS. THIS DRAWING MUST ALWAYS BE READ IN CONJUNCTION WITH ALL RELEVANT PROJECT DETAILS. ALL DIMENSIONS MUST BE CHECKED ON SITE PRIOR TO COMMENCEMENT. PLEASE REPORT ANY DISCREPANCY TO THE ARCHITECT OR CONTRACT ADMINISTRATOR

© COPYRIGHT XTERIORSCAPES 2025

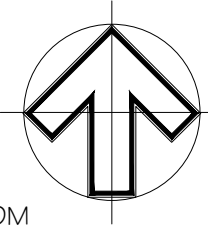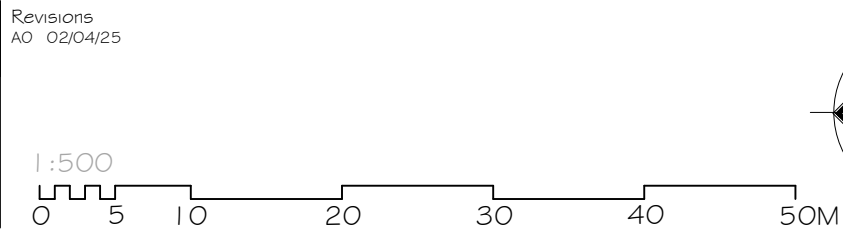

Drawing Street Tree and Lighting Plan		Project Date Jun 2021	
Project/Client Riverstone Subdivision Yoursection Ltd		Scale @ A3 1:500	
Job reference Drawing number 20082 ST LT-005		Revision AO	Purpose of Issue Approval

xteriorscapes
LANDSCAPE ARCHITECTS

441 Papanui Road, PO Box 36-511
Christchurch 8146

m: 021 433 418 t: 03 421 8460
hayden@xteriorscapes.nz
www.xteriorscapes.nz





- Key:
- Proposed Tree
 - Garden Bed
 - Grass
 - Proposed Lot
 - Street light

PLEASE NOTE

FOR CONSTRUCTION PURPOSES USE ONLY FIGURED DIMENSIONS. THIS DRAWING MUST ALWAYS BE READ IN CONJUNCTION WITH ALL RELEVANT PROJECT DETAILS. ALL DIMENSIONS MUST BE CHECKED ON SITE PRIOR TO COMMENCEMENT. PLEASE REPORT ANY DISCREPANCY TO THE ARCHITECT OR CONTRACT ADMINISTRATOR

© COPYRIGHT XTERIORSCAPES 2025

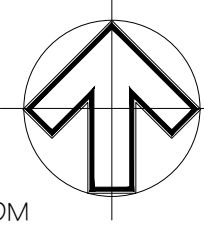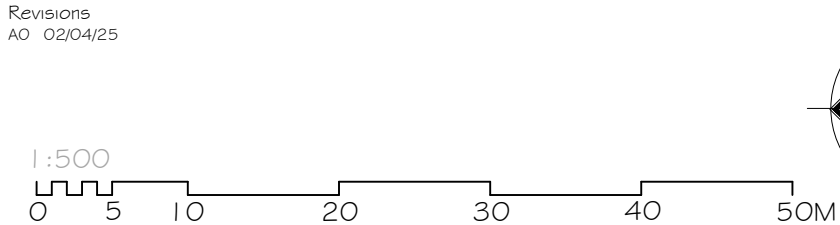


Drawing Street Tree and Lighting Plan		Project Date Jun 2021	
Project/Client Riverstone Subdivision Yoursection Ltd		Scale @ A3 1:500	
Job reference Drawing number 20082 ST LT-006		Revision AO	Purpose of Issue Approval

xteriorscapes
LANDSCAPE ARCHITECTS

441 Papanui Road, PO Box 36-511
Christchurch 8146

m: 021 433 418 t: 03 421 8460
hayden@xteriorscapes.nz
www.xteriorscapes.nz

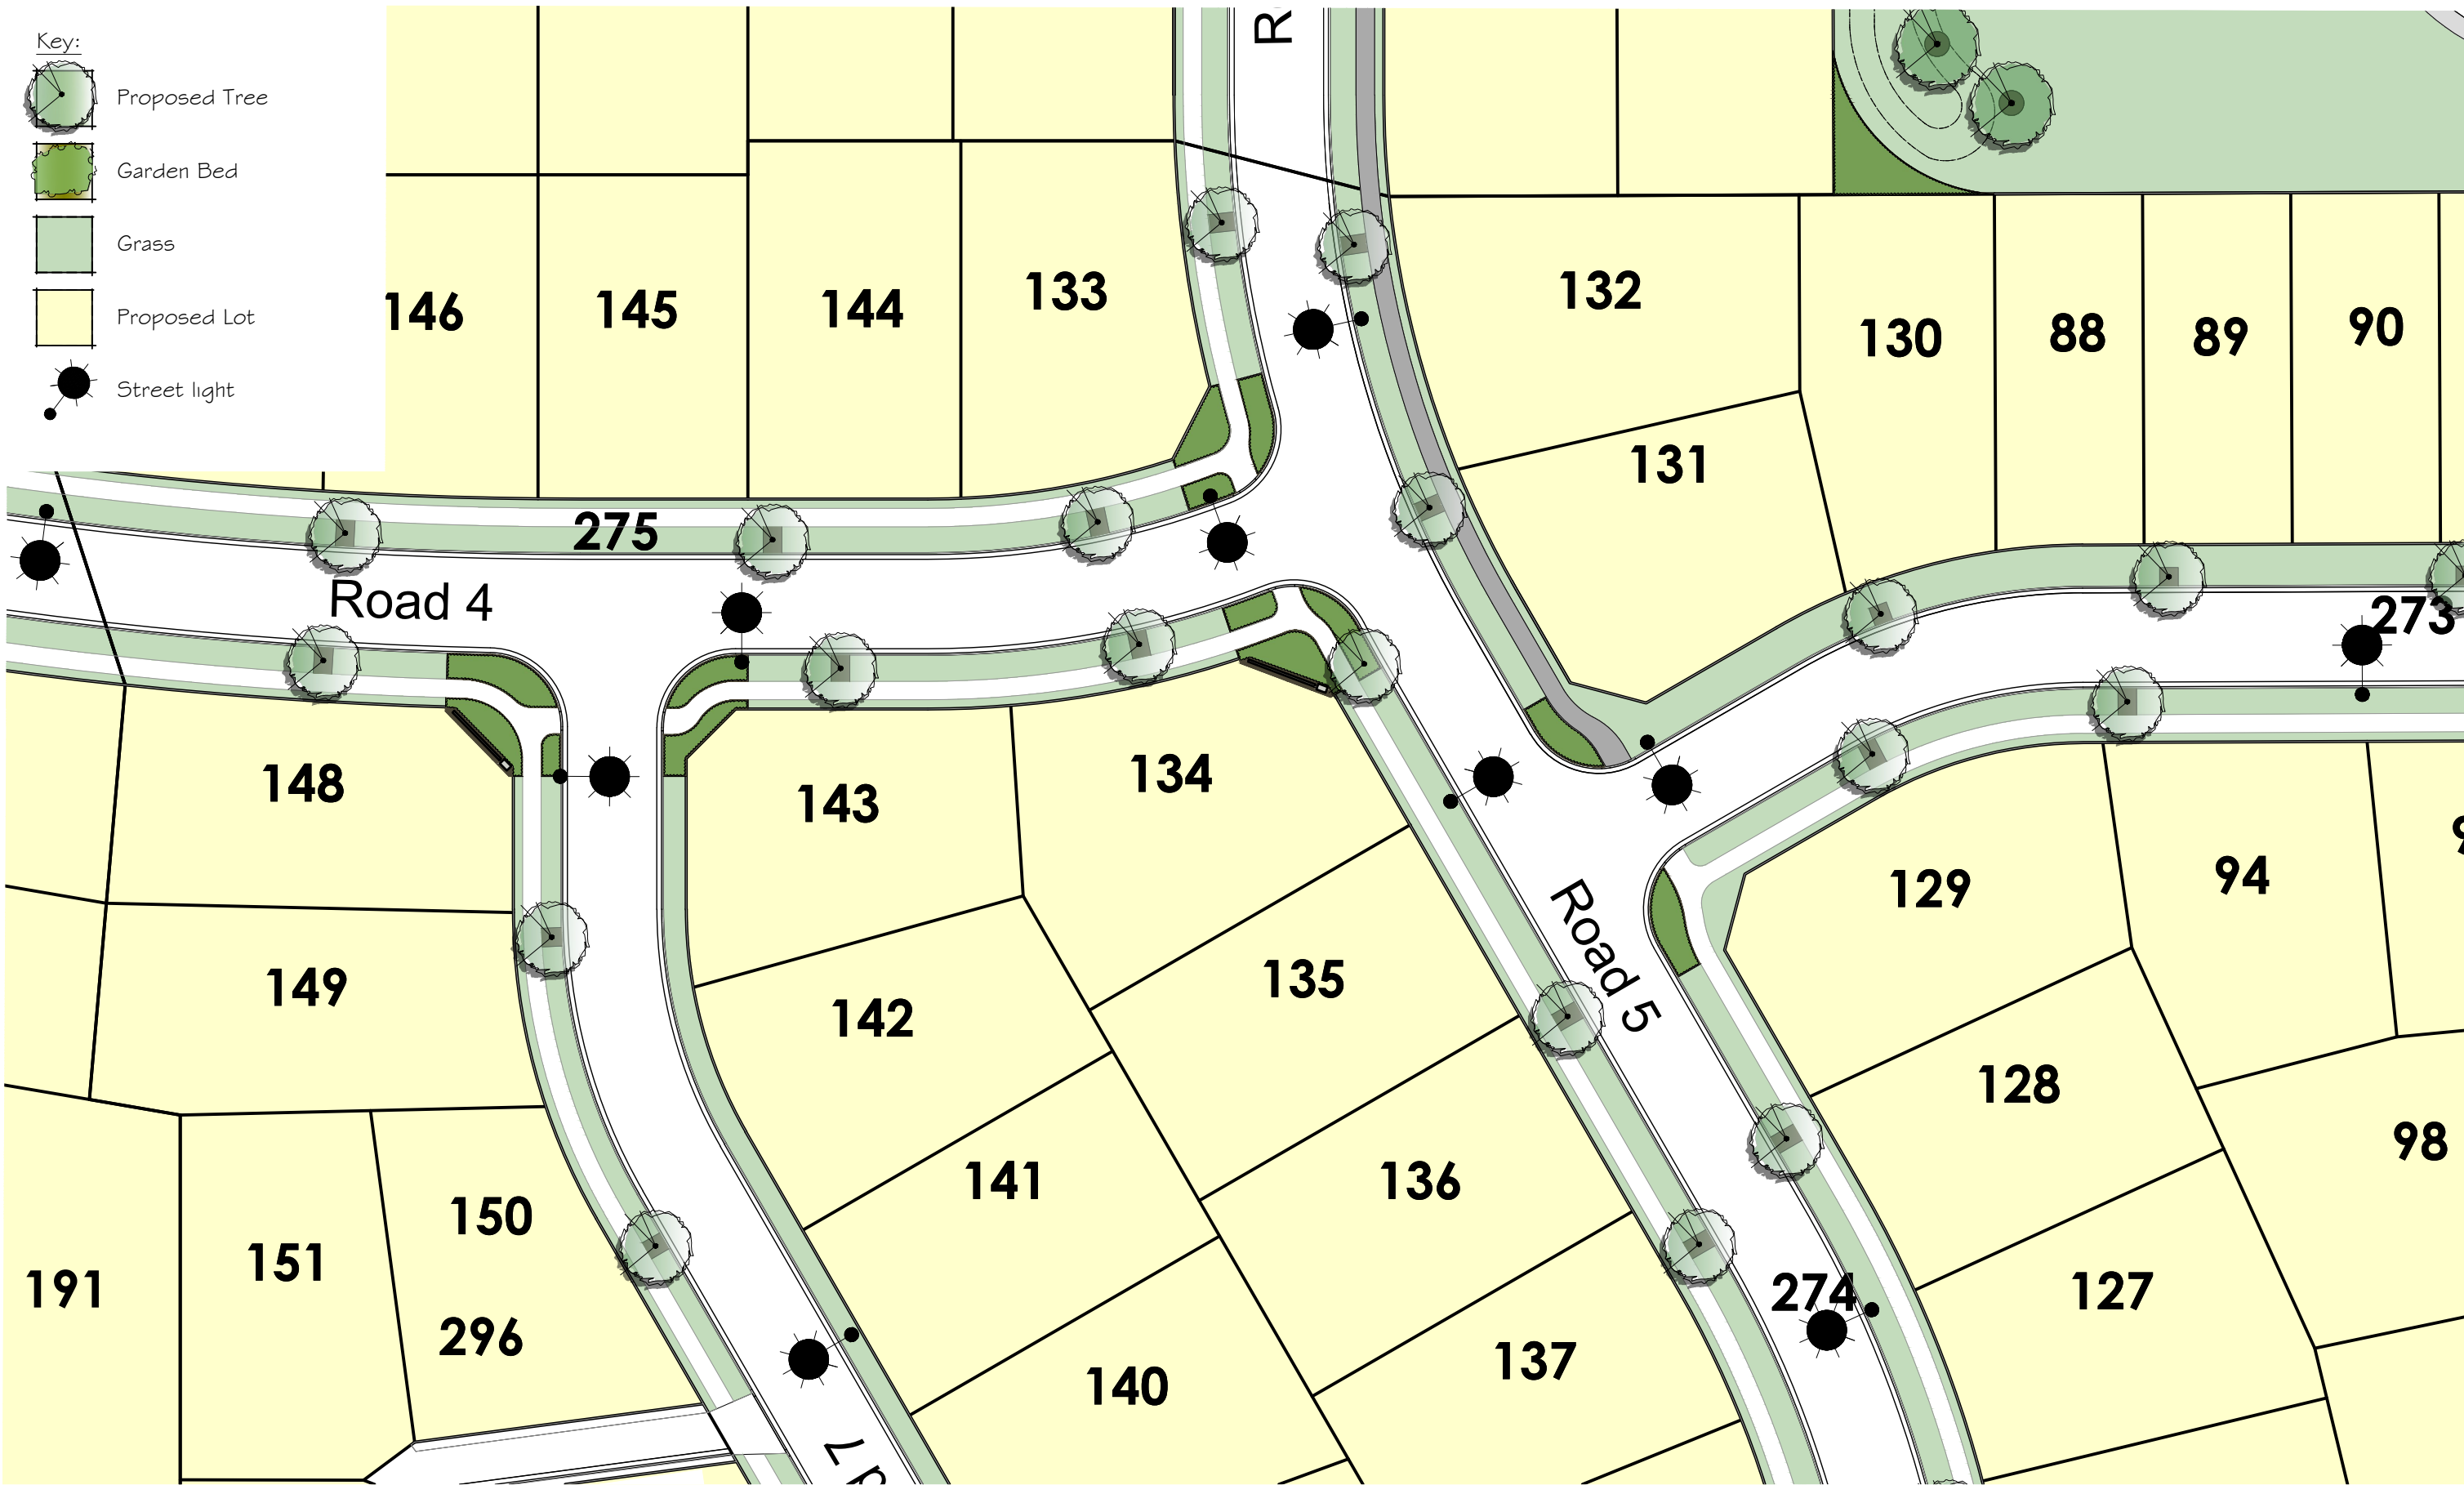

Key:

- Proposed Tree
- Garden Bed
- Grass
- Proposed Lot
- Street light

PLEASE NOTE

FOR CONSTRUCTION PURPOSES USE ONLY FIGURED DIMENSIONS. THIS DRAWING MUST ALWAYS BE READ IN CONJUNCTION WITH ALL RELEVANT PROJECT DETAILS. ALL DIMENSIONS MUST BE CHECKED ON SITE PRIOR TO COMMENCEMENT. PLEASE REPORT ANY DISCREPANCY TO THE ARCHITECT OR CONTRACT ADMINISTRATOR

© COPYRIGHT XTERIORSCAPES 2025

Revisions
AO 02/04/25


1:500

Drawing Street Tree and Lighting Plan		Project Date Jun 2021	
Project/Client Riverstone Subdivision Yoursection Ltd		Scale @ A3 1:500	
Job reference Drawing number 20082 ST LT-007		Revision AO	Purpose of Issue Approval

xteriorscapes
LANDSCAPE ARCHITECTS

441 Papanui Road, PO Box 36-511
Christchurch 8146



m: 021 433 418 t: 03 421 8460
hayden@xteriorscapes.nz
www.xteriorscapes.nz

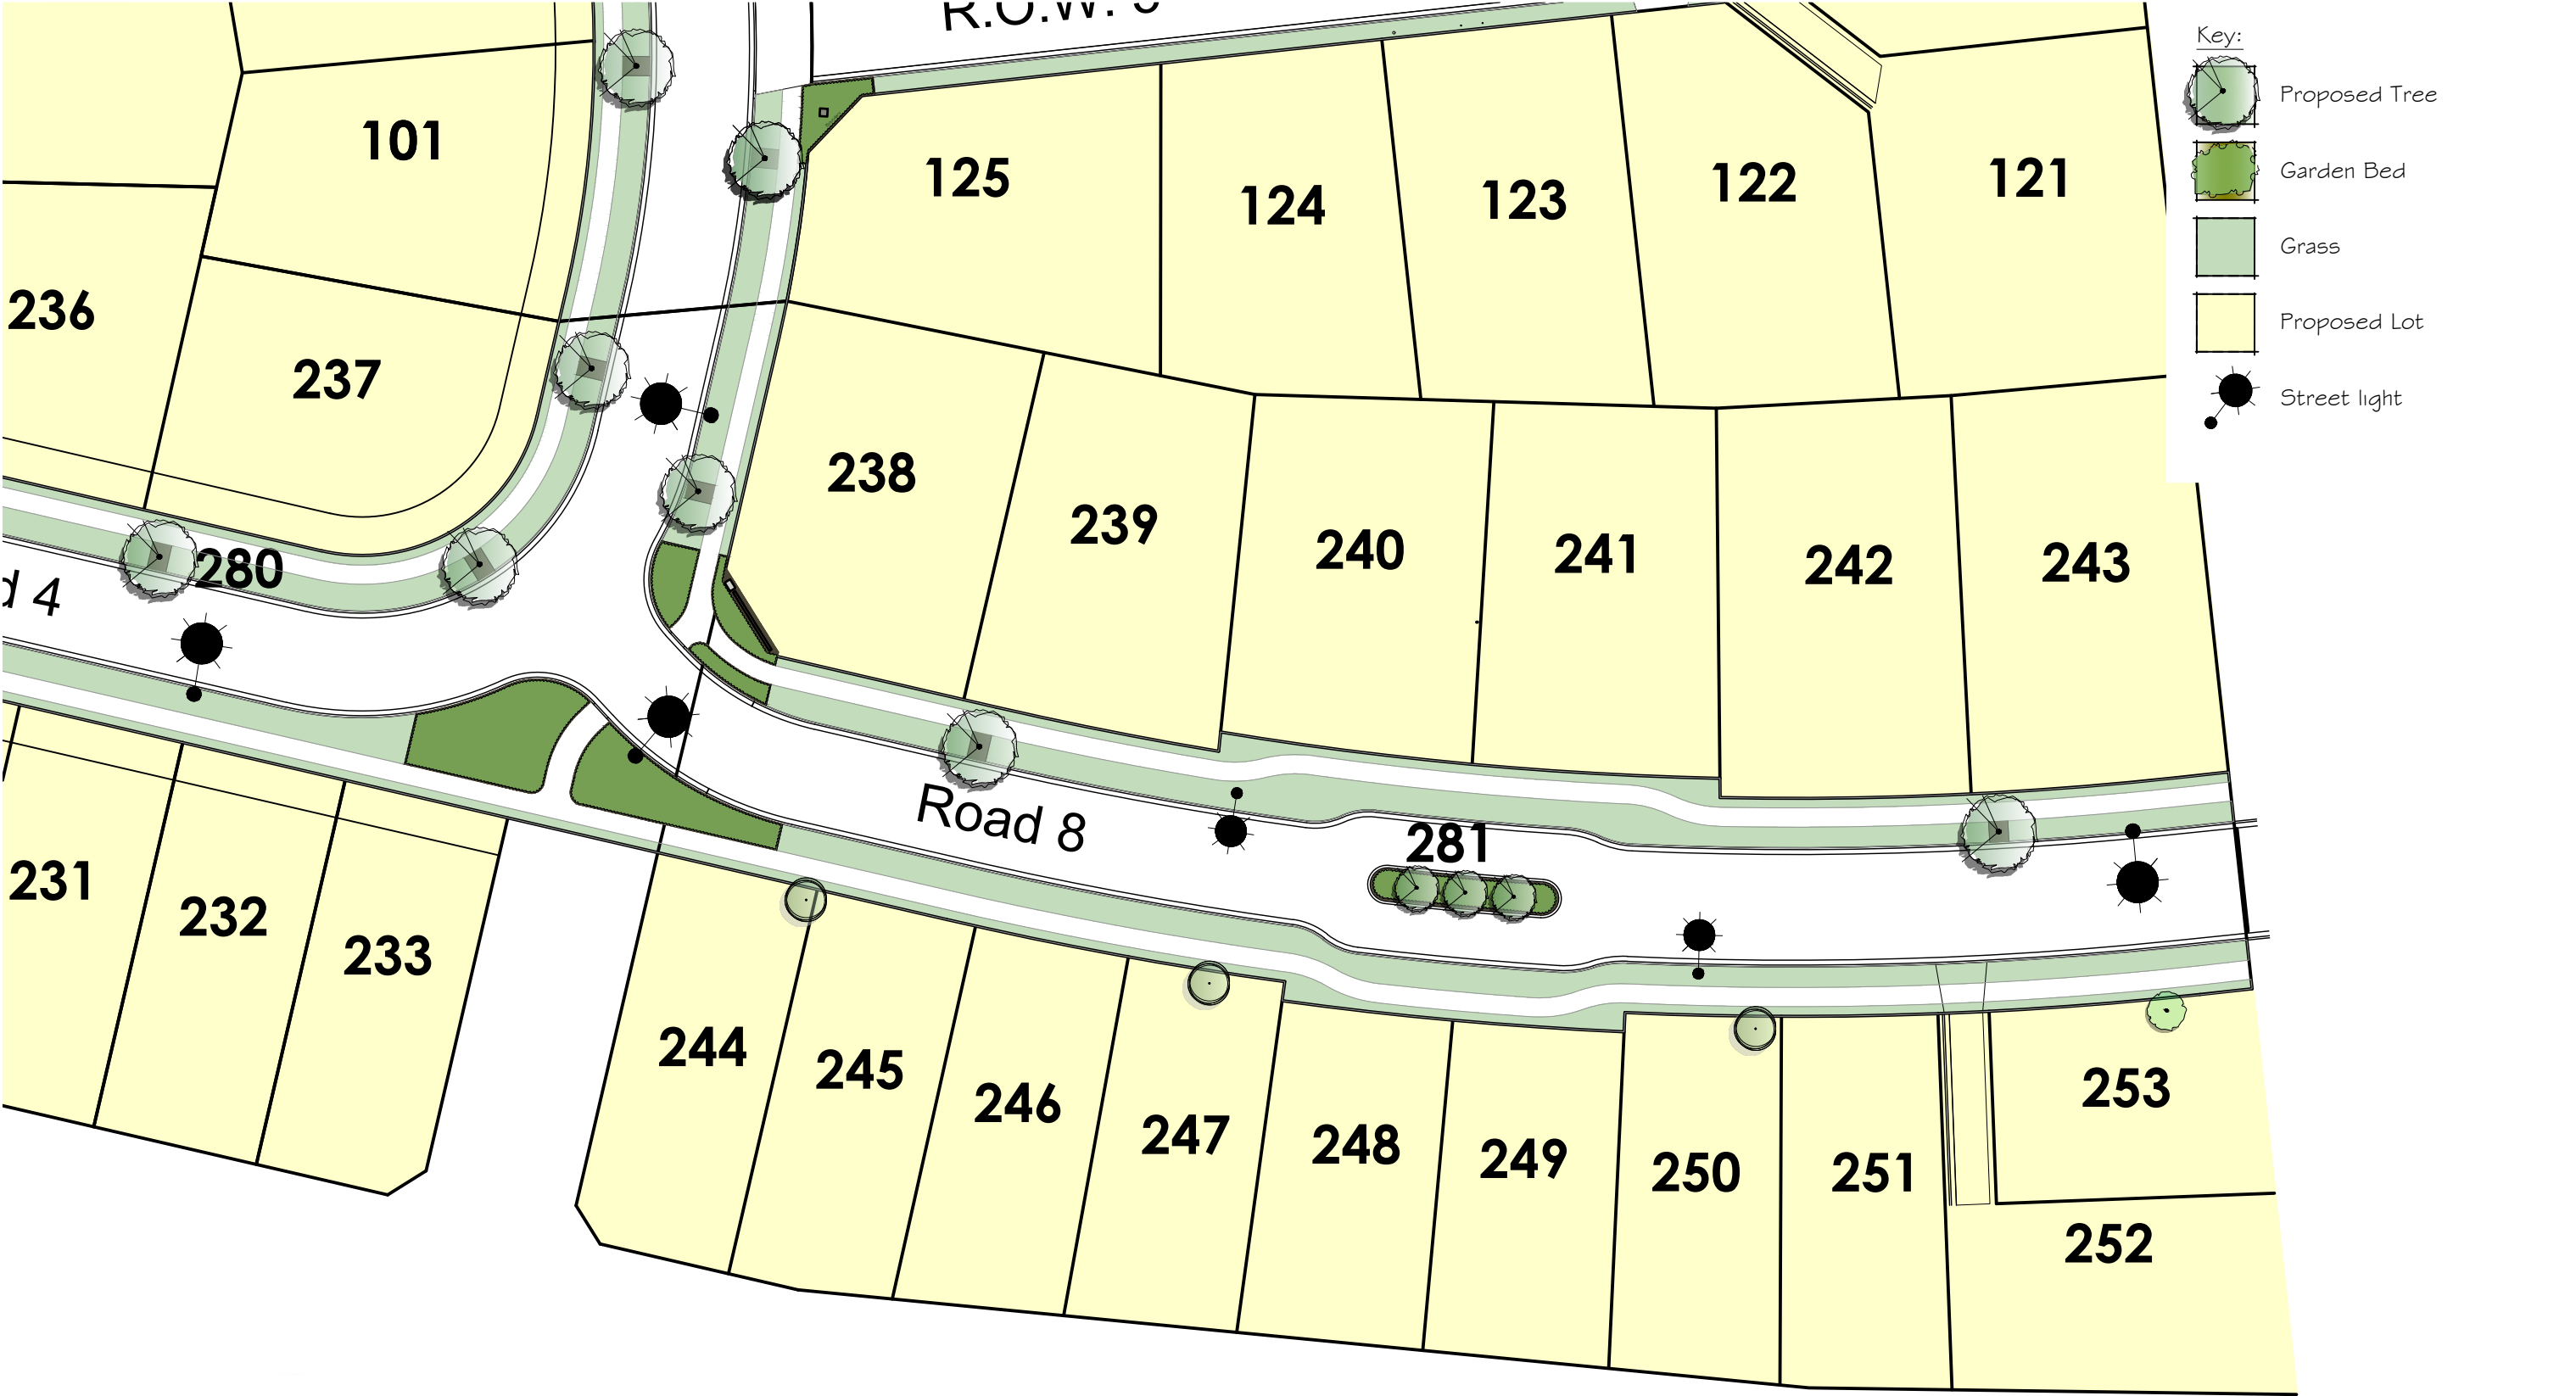

PLEASE NOTE

FOR CONSTRUCTION PURPOSES USE ONLY FIGURED DIMENSIONS. THIS DRAWING MUST ALWAYS BE READ IN CONJUNCTION WITH ALL RELEVANT PROJECT DETAILS. ALL DIMENSIONS MUST BE CHECKED ON SITE PRIOR TO COMMENCEMENT. PLEASE REPORT ANY DISCREPANCY TO THE ARCHITECT OR CONTRACT ADMINISTRATOR

© COPYRIGHT XTERIORSCAPES 2025

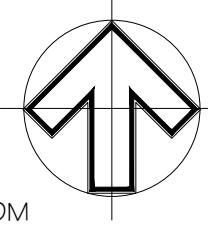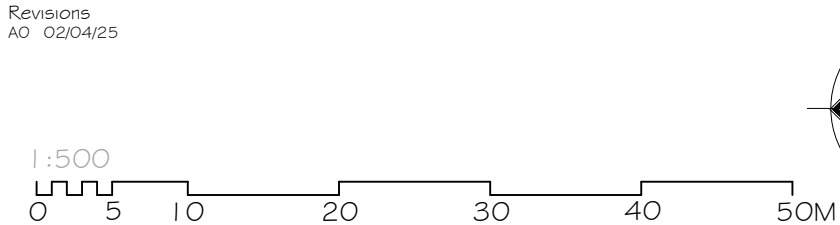


Drawing Street Tree and Lighting Plan		Project Date Jun 2021	
Project/Client Riverstone Subdivision Yoursection Ltd		Scale @ A3 1:500	
Job reference Drawing number 20082 ST LT-008		Revision AO	Purpose of Issue Approval

xteriorscapes
LANDSCAPE ARCHITECTS

441 Papanui Road, PO Box 36-511
Christchurch 8146


m: 021 433 418 t: 03 421 8460
hayden@xteriorscapes.nz
www.xteriorscapes.nz

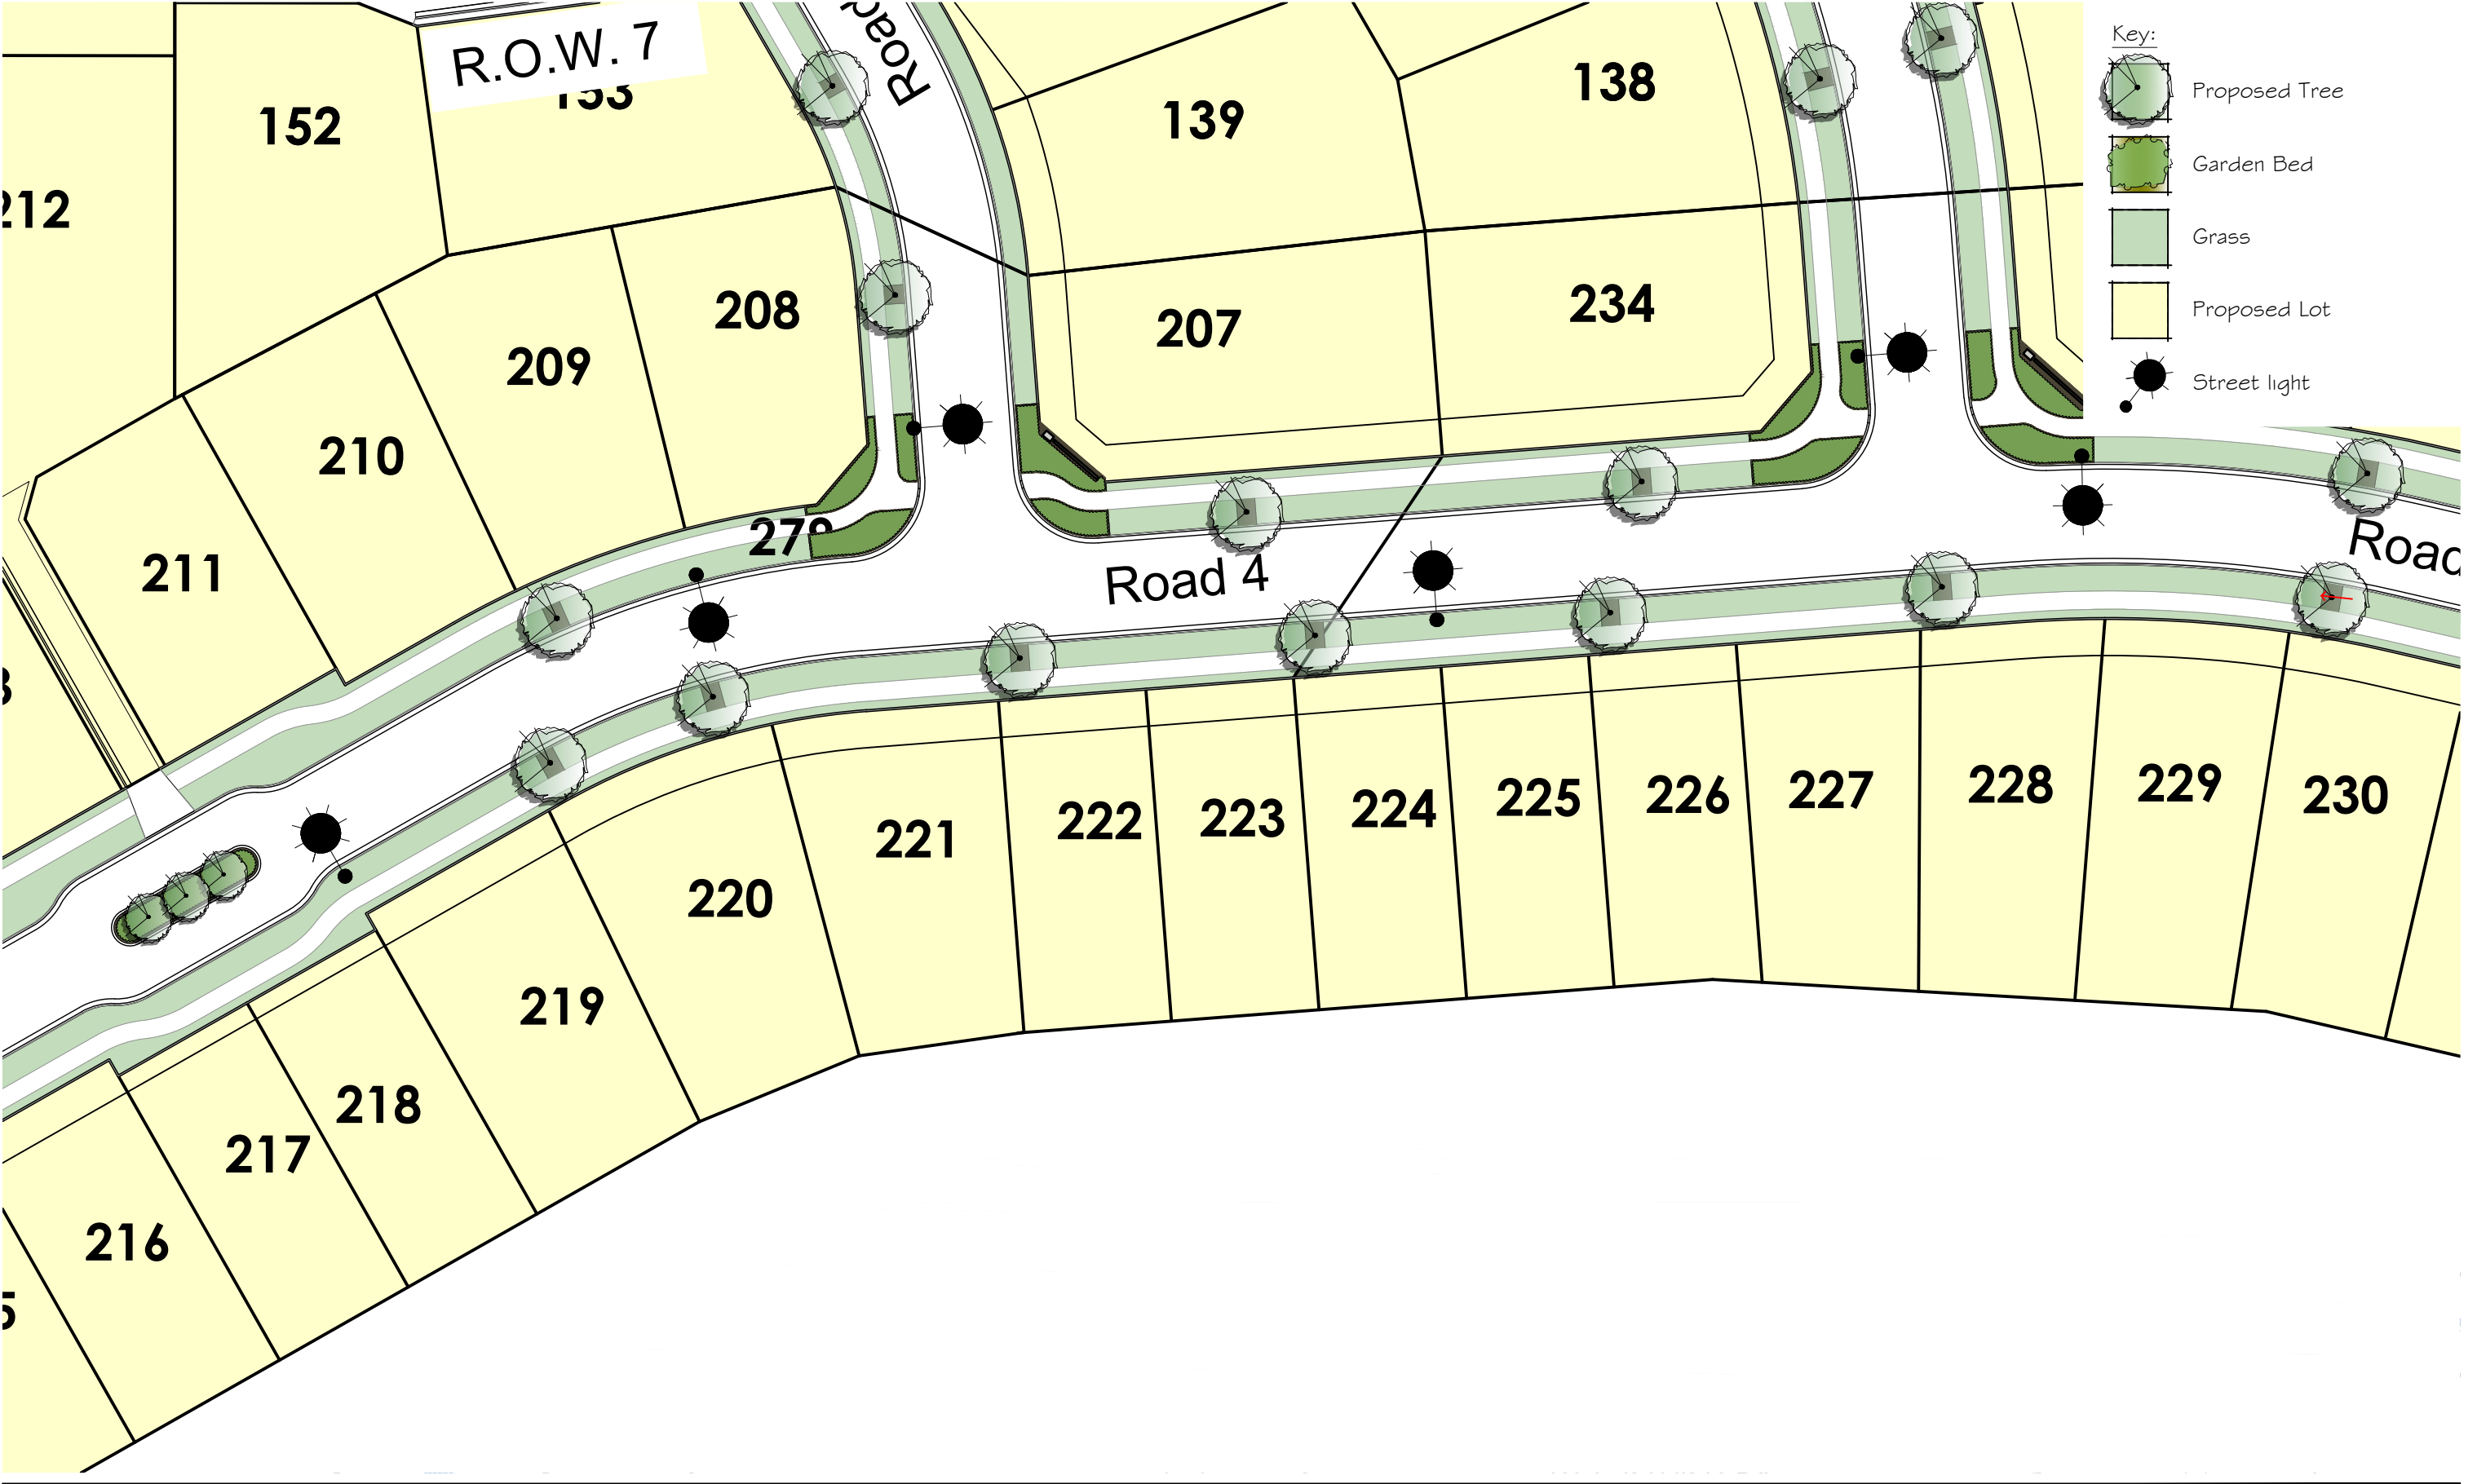

PLEASE NOTE

FOR CONSTRUCTION PURPOSES USE ONLY FIGURED DIMENSIONS. THIS DRAWING MUST ALWAYS BE READ IN CONJUNCTION WITH ALL RELEVANT PROJECT DETAILS. ALL DIMENSIONS MUST BE CHECKED ON SITE PRIOR TO COMMENCEMENT. PLEASE REPORT ANY DISCREPANCY TO THE ARCHITECT OR CONTRACT ADMINISTRATOR

© COPYRIGHT XTERIORSCAPES 2025

 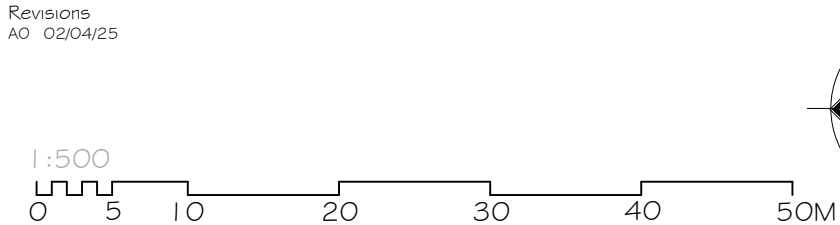

 
 



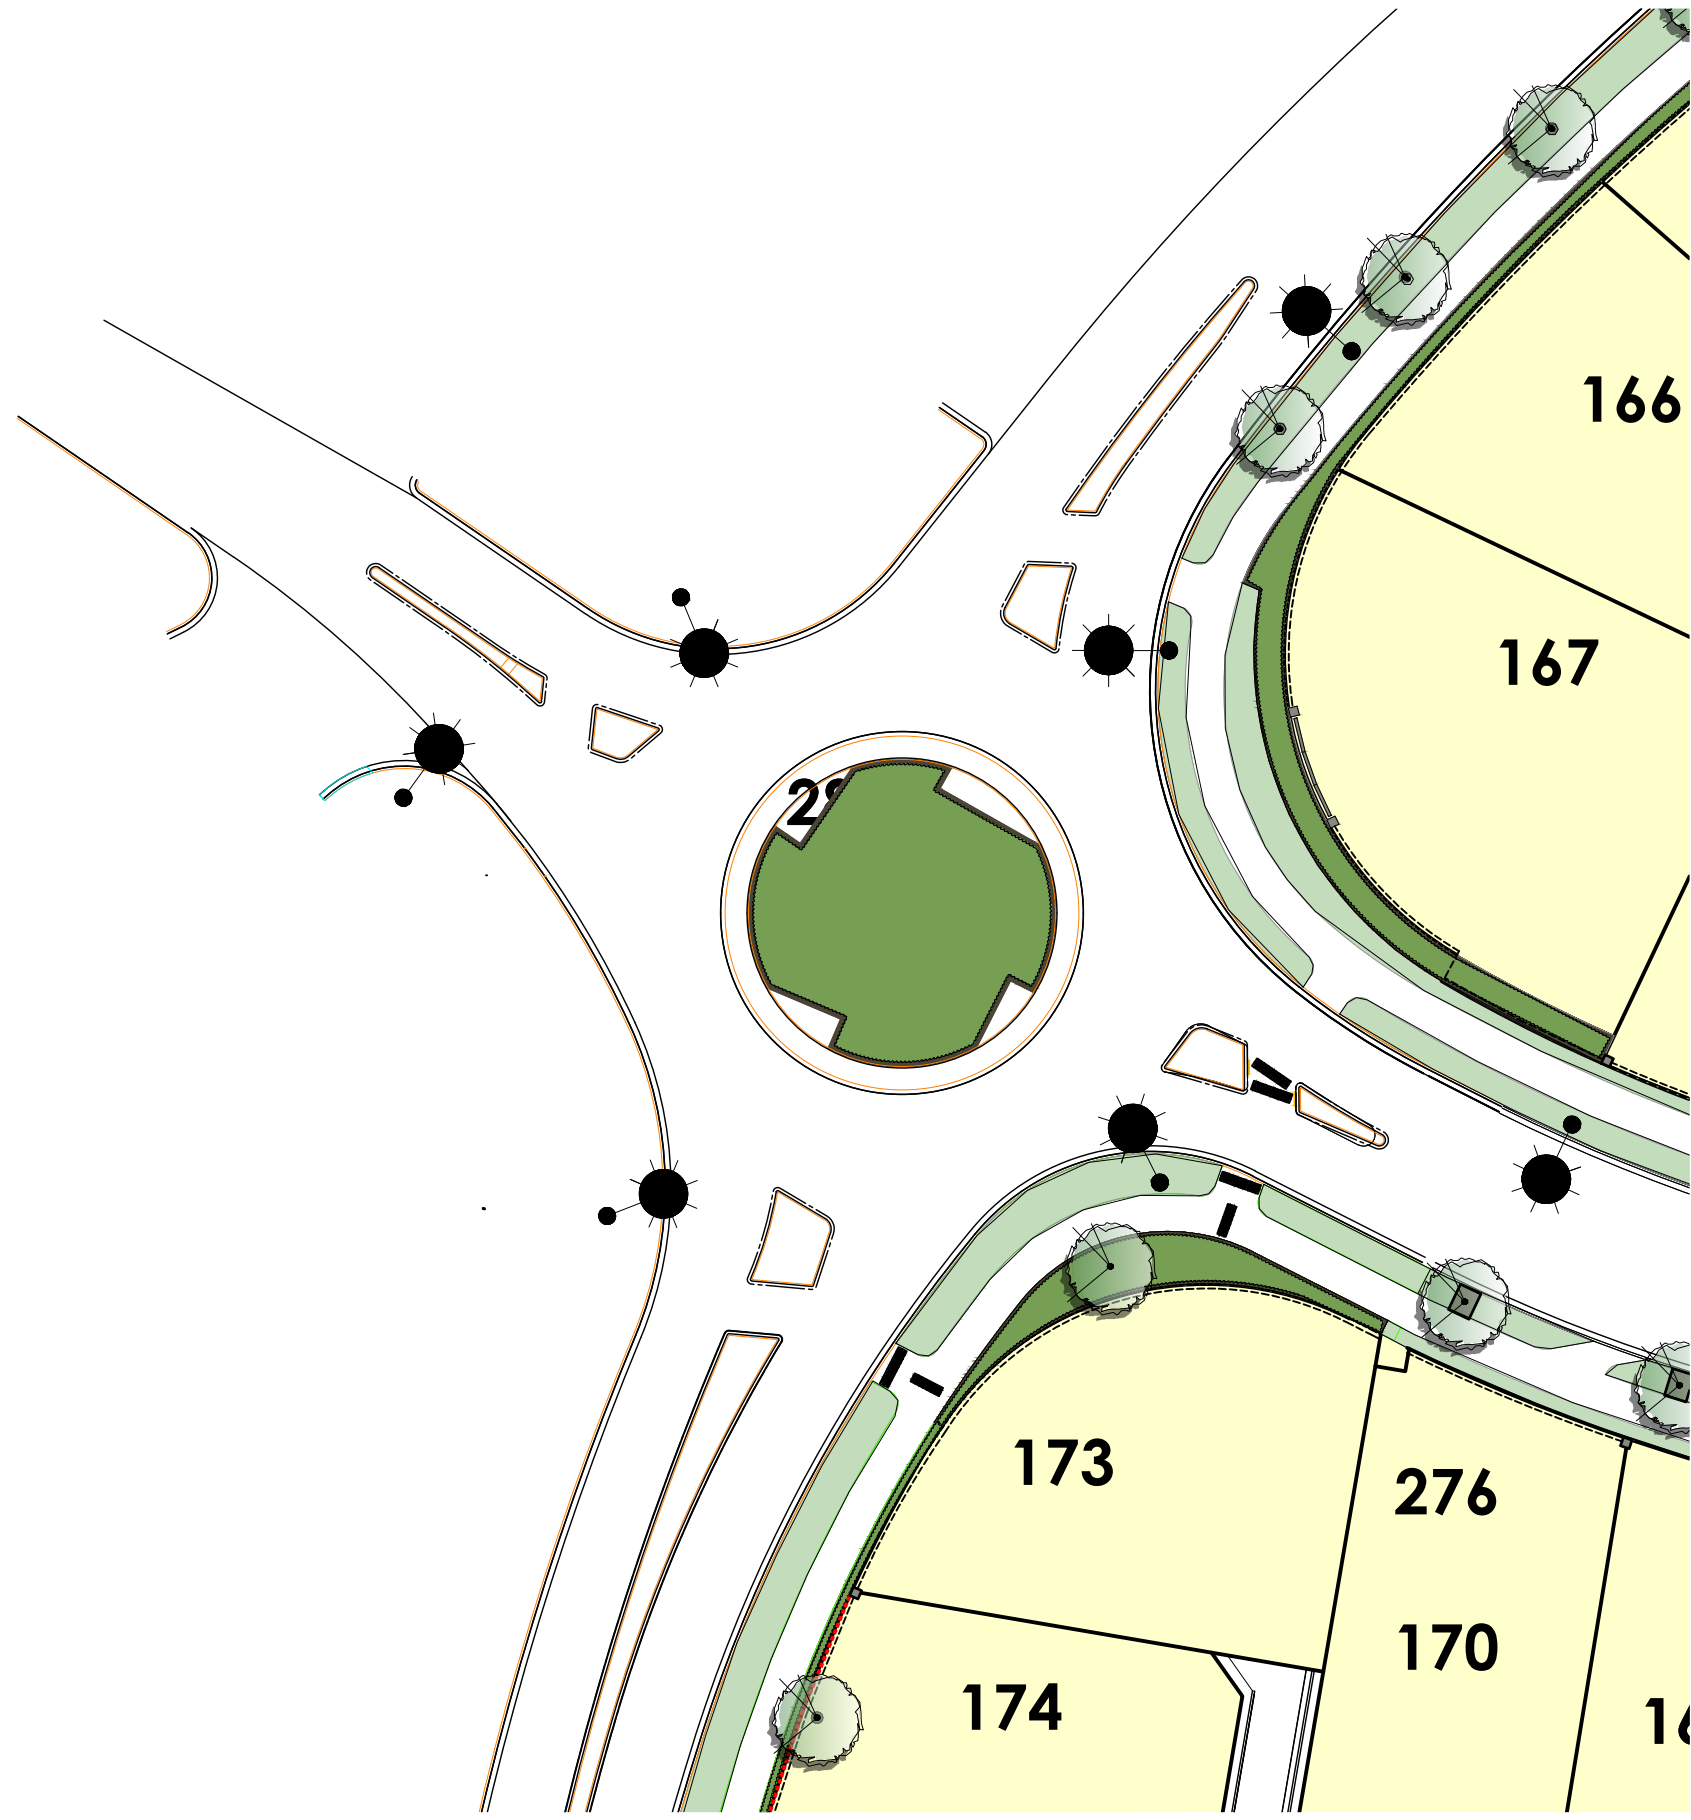
Drawing Street Tree and Lighting Plan		Project Date Jun 2021	
Project/Client Riverstone Subdivision Yoursection Ltd		Scale @ A3 1:500	
Job reference Drawing number 20082 ST LT-009		Revision AO	Purpose of Issue Approval

441 Papanui Road, PO Box 36-511
Christchurch 8146

m: 021 433 418 t: 03 421 8460
hayden@xteriorscapes.nz
www.xteriorscapes.nz

Key:


-  Proposed Tree
-  Garden Bed
-  Grass
-  Proposed Lot
-  Street light



PLEASE NOTE

FOR CONSTRUCTION PURPOSES USE ONLY FIGURED DIMENSIONS. THIS DRAWING MUST ALWAYS BE READ IN CONJUNCTION WITH ALL RELEVANT PROJECT DETAILS. ALL DIMENSIONS MUST BE CHECKED ON SITE PRIOR TO COMMENCEMENT. PLEASE REPORT ANY DISCREPANCY TO THE ARCHITECT OR CONTRACT ADMINISTRATOR

© COPYRIGHT XTERIORSCAPES 2025

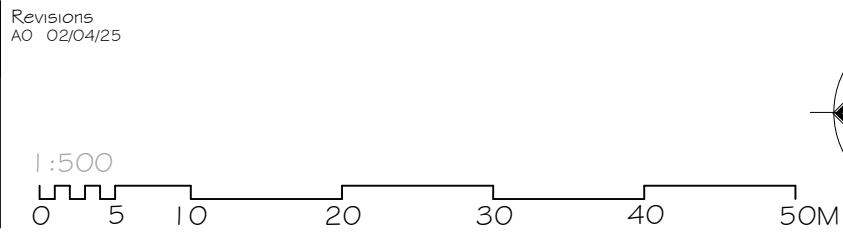

Drawing Street Tree and Lighting Plan		Project Date Jun 2021	
Project/Client Riverstone Subdivision Yoursection Ltd		Scale @ A3 1:500	
Job reference Drawing number 20082 ST LT-010		Revision AO	Purpose of Issue Approval

 
 
 
 



xteriorscapes
LANDSCAPE ARCHITECTS

441 Papanui Road, PO Box 36-511
Christchurch 8146

m: 021 433 418 t: 03 421 8460
hayden@xteriorscapes.nz
www.xteriorscapes.nz

Key:

-  Proposed Tree
-  Garden Bed
-  Grass
-  Proposed Lot
-  Street light



 

PLEASE NOTE

FOR CONSTRUCTION PURPOSES USE ONLY FIGURED DIMENSIONS. THIS DRAWING MUST ALWAYS BE READ IN CONJUNCTION WITH ALL RELEVANT PROJECT DETAILS. ALL DIMENSIONS MUST BE CHECKED ON SITE PRIOR TO COMMENCEMENT. PLEASE REPORT ANY DISCREPANCY TO THE ARCHITECT OR CONTRACT ADMINISTRATOR

© COPYRIGHT XTERIORSCAPES 2025

Revisions
AO 02/04/25

1:500

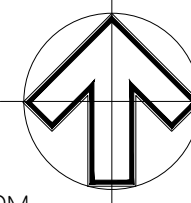Drawing Street Tree and Lighting Plan		Project Date Jun 2021	
Project/Client Riverstone Subdivision Yoursection Ltd		Scale @ A3 1:500	
Job reference Drawing number 20082 ST LT-011		Revision AO	Purpose of Issue Approval

 
 
 
 



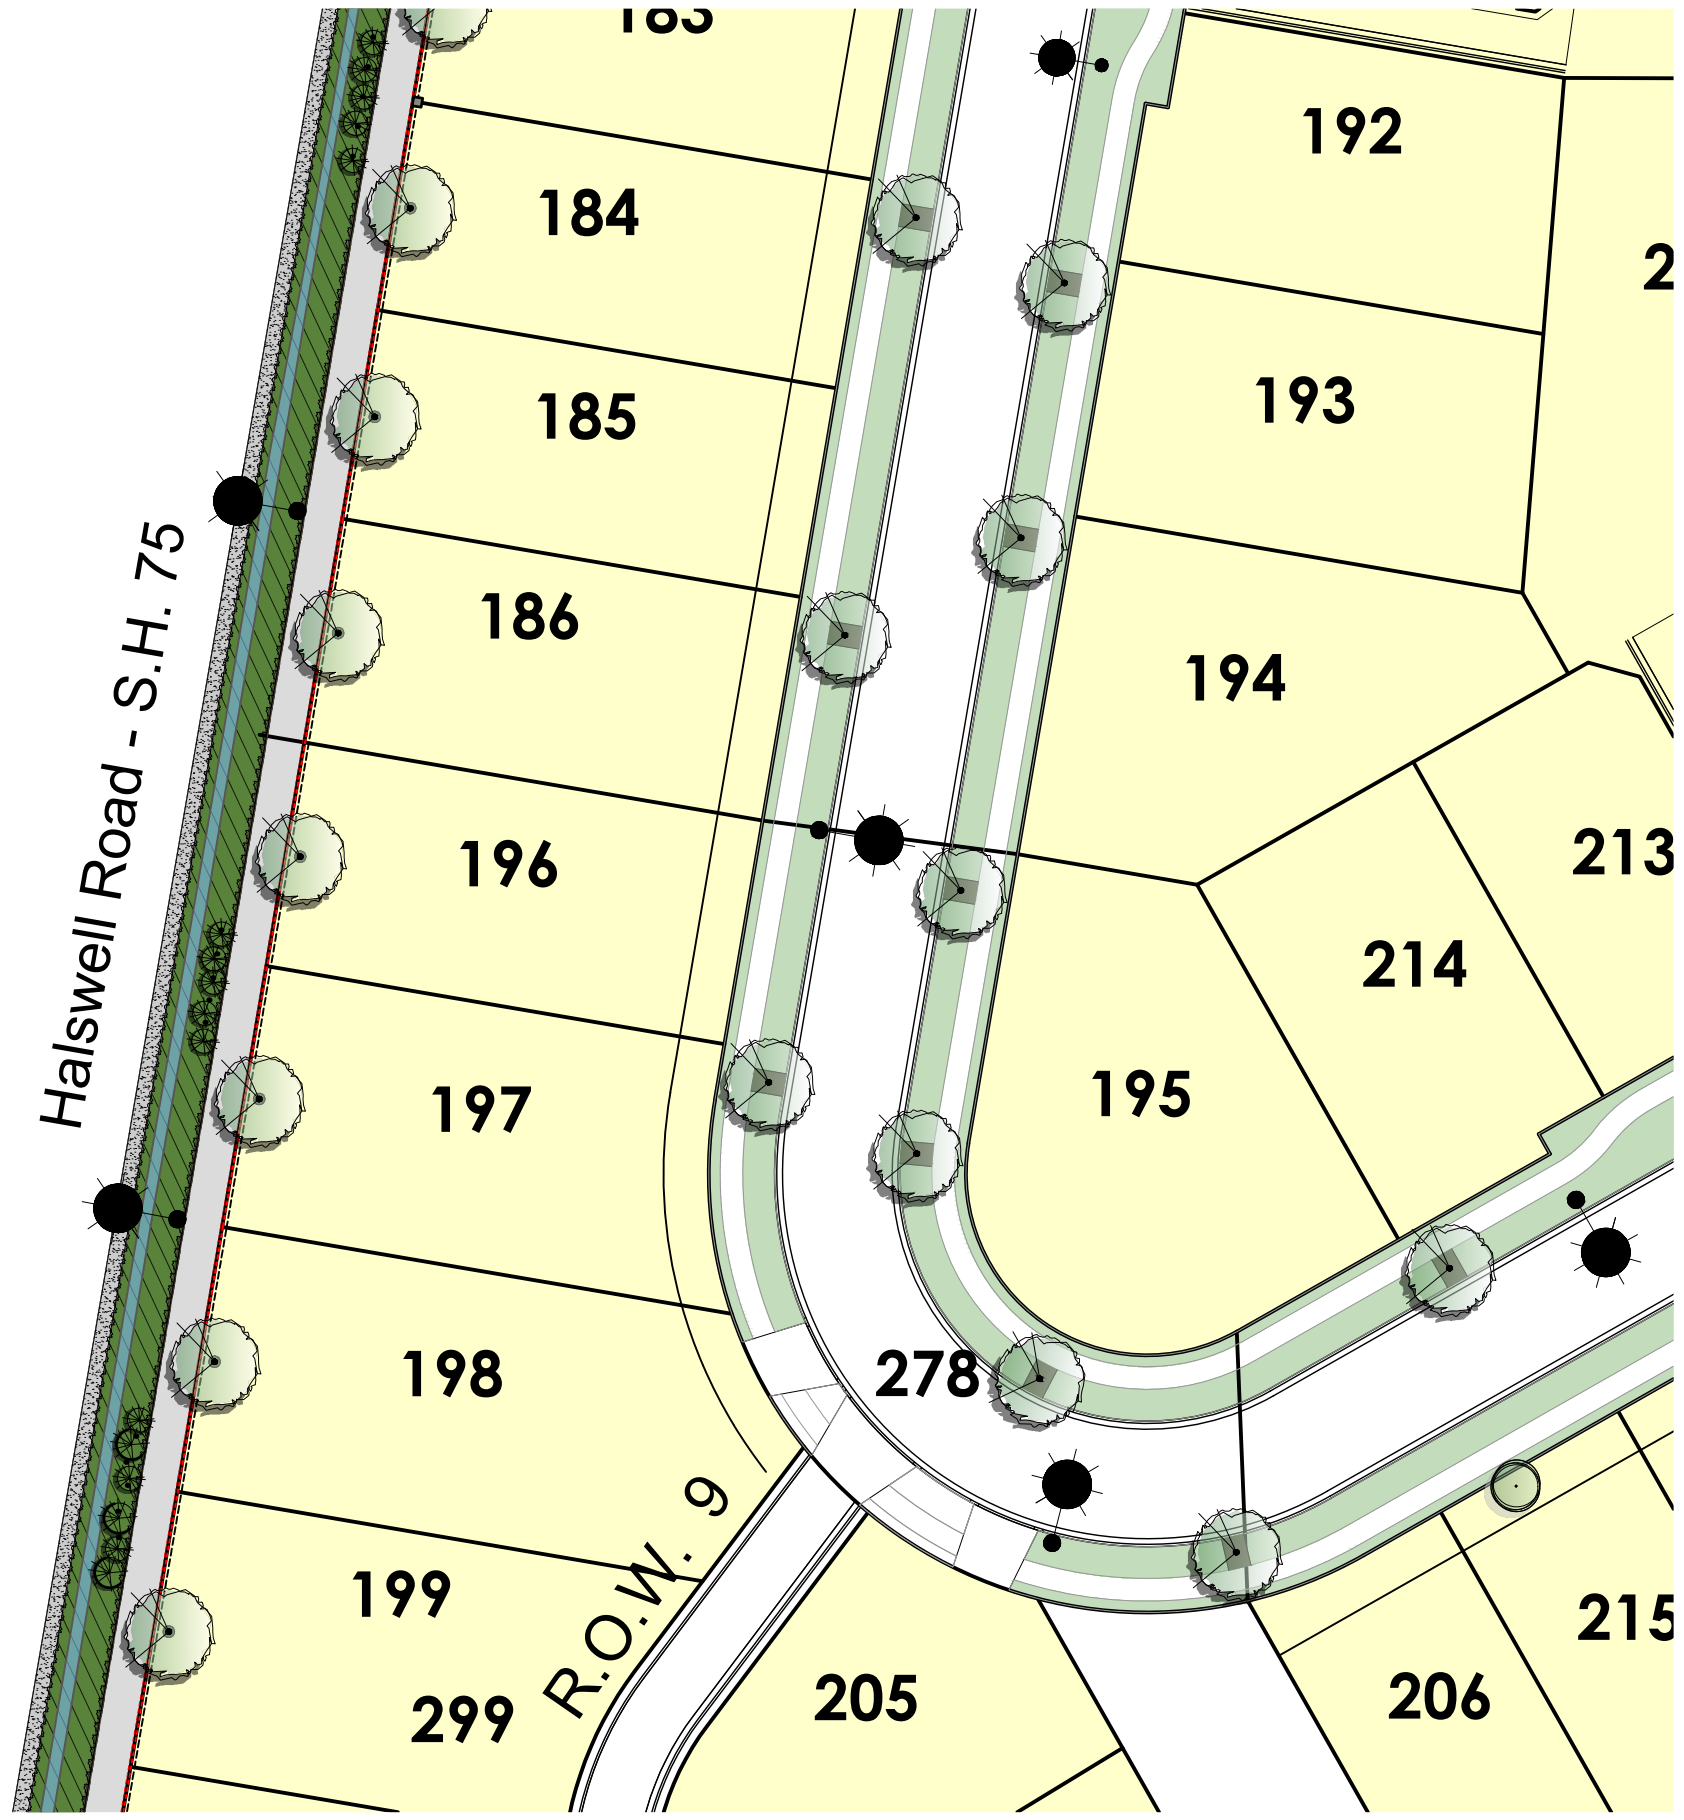
xteriorscapes
LANDSCAPE ARCHITECTS

441 Papanui Road, PO Box 36-511
Christchurch 8146

m: 021 433 418 t: 03 421 8460
hayden@xteriorscapes.nz
www.xteriorscapes.nz

Key:


-  Proposed Tree
-  Garden Bed
-  Grass
-  Proposed Lot
-  Street light



PLEASE NOTE

FOR CONSTRUCTION PURPOSES USE ONLY FIGURED DIMENSIONS. THIS DRAWING MUST ALWAYS BE READ IN CONJUNCTION WITH ALL RELEVANT PROJECT DETAILS. ALL DIMENSIONS MUST BE CHECKED ON SITE PRIOR TO COMMENCEMENT. PLEASE REPORT ANY DISCREPANCY TO THE ARCHITECT OR CONTRACT ADMINISTRATOR

© COPYRIGHT XTERIORSCAPES 2025

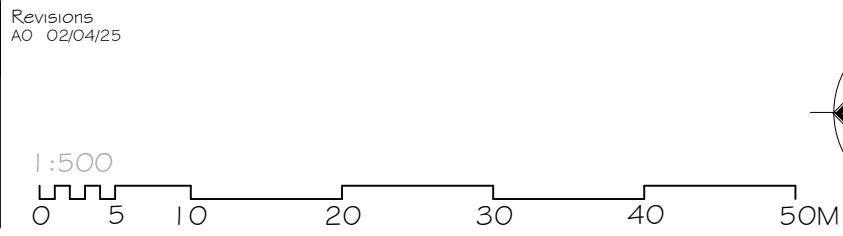

Drawing Street Tree and Lighting Plan		Project Date Jun 2021	
Project/Client Riverstone Subdivision Yoursection Ltd		Scale @ A3 1:500	
Job reference Drawing number 20082 ST LT-012		Revision AO	Purpose of Issue Approval

 

 
 



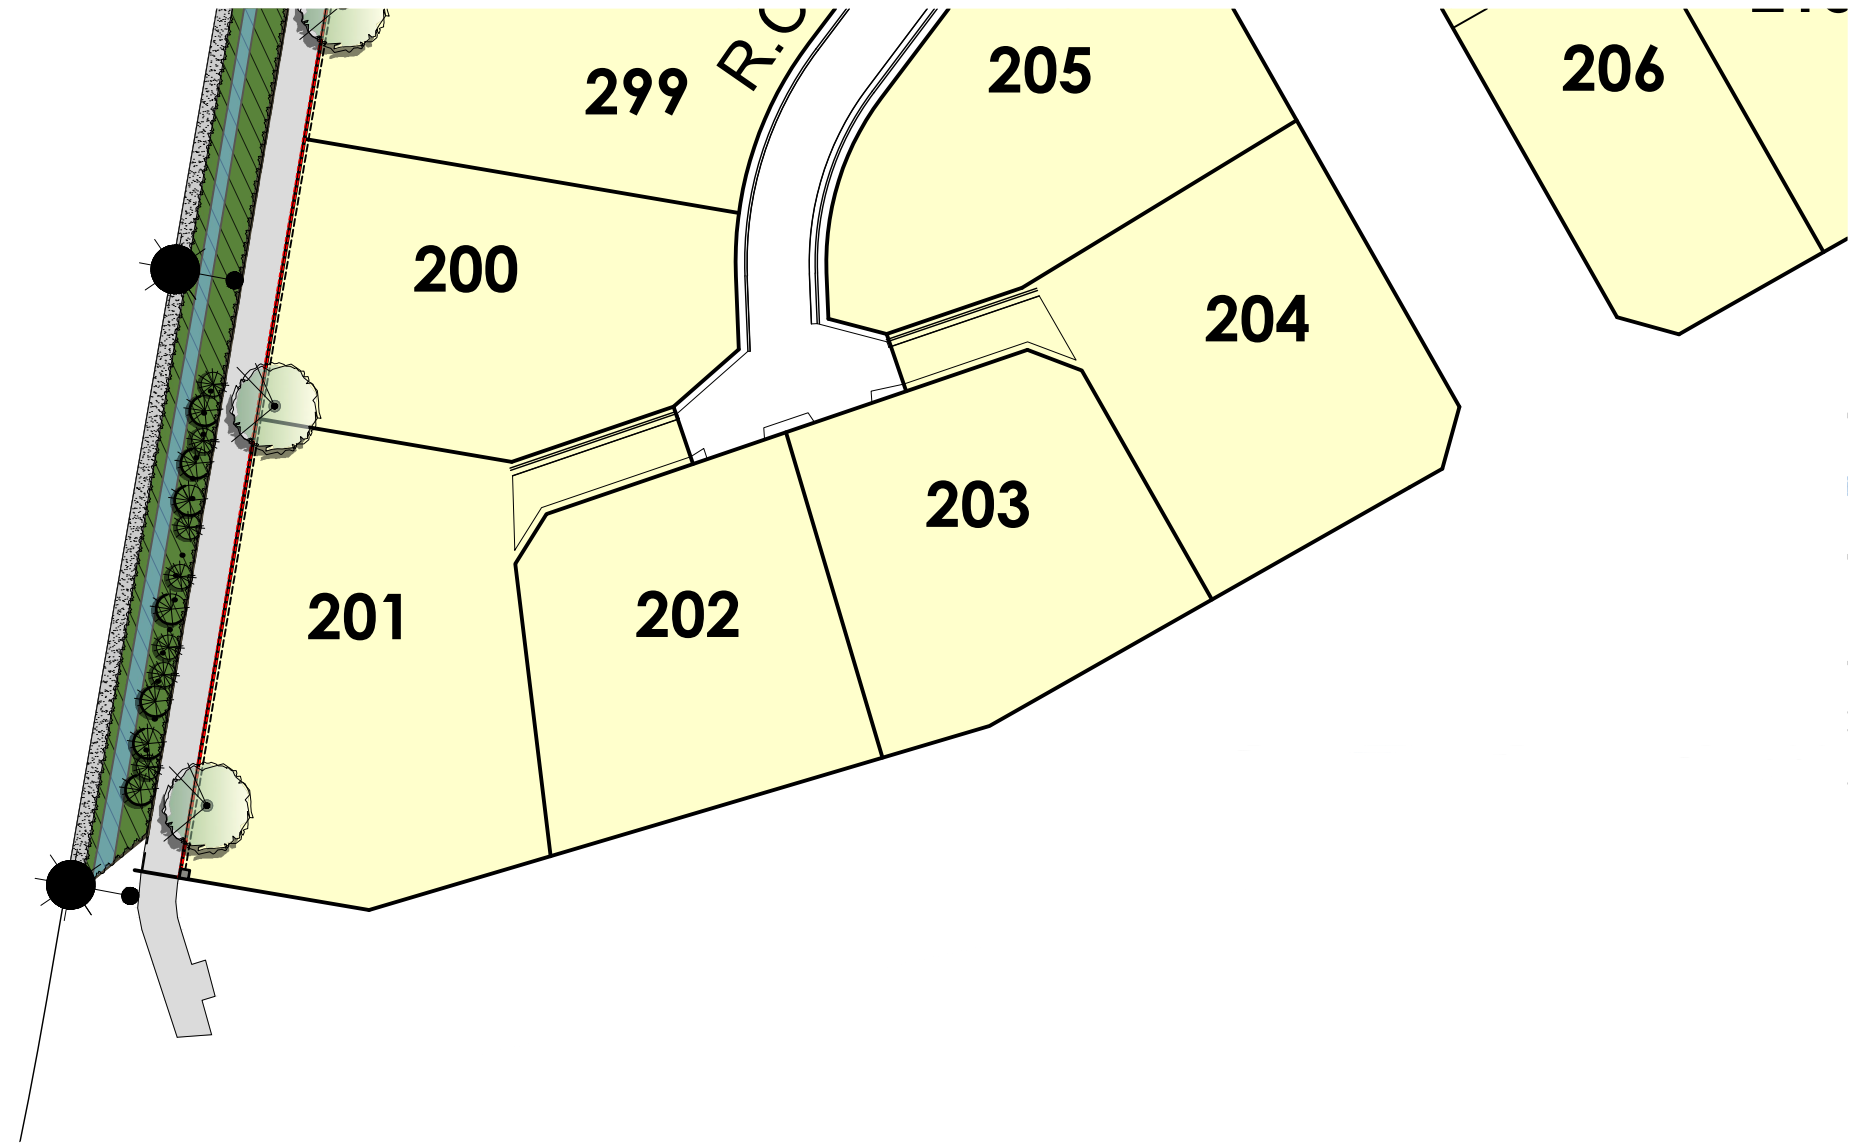
xteriorscapes
LANDSCAPE ARCHITECTS

441 Papanui Road, PO Box 36-511
Christchurch 8146

m: 021 433 418 t: 03 421 8460
hayden@xteriorscapes.nz
www.xteriorscapes.nz

Key:

-  Proposed Tree
-  Garden Bed
-  Grass
-  Proposed Lot
-  Street light


 


PLEASE NOTE

FOR CONSTRUCTION PURPOSES USE ONLY FIGURED DIMENSIONS. THIS DRAWING MUST ALWAYS BE READ IN CONJUNCTION WITH ALL RELEVANT PROJECT DETAILS. ALL DIMENSIONS MUST BE CHECKED ON SITE PRIOR TO COMMENCEMENT. PLEASE REPORT ANY DISCREPANCY TO THE ARCHITECT OR CONTRACT ADMINISTRATOR

Revisions
AO 02/04/25

1:500

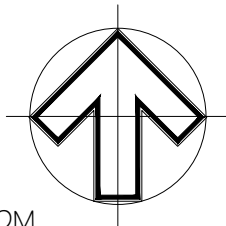

Drawing Street Tree and Lighting Plan		Project Date Jun 2021	
Project/Client Riverstone Subdivision Yoursection Ltd		Scale @ A3 1:500	
Job reference Drawing number 20082 ST LT-013		Revision AO	Purpose of Issue Approval



441 Papanui Road, PO Box 36-511
Christchurch 8146

m: 021 433 418 t: 03 421 8460
hayden@xteriorscapes.nz
www.xteriorscapes.nz