


PLEASE NOTE

FOR CONSTRUCTION PURPOSES USE ONLY FIGURED DIMENSIONS. THIS DRAWING MUST ALWAYS BE READ IN CONJUNCTION WITH ALL RELEVANT PROJECT DETAILS. ALL DIMENSIONS MUST BE CHECKED ON SITE PRIOR TO COMMENCEMENT. PLEASE REPORT ANY DISCREPANCY TO THE ARCHITECT OR CONTRACT ADMINISTRATOR

© COPYRIGHT XTERIORSCAPES 2022

Revisions
AO 26/10/22 Initial Design

NTS
NTS

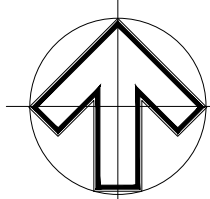






Drawing Street Tree & Lighting Plan		Project Date Jun 2021
Project/Client Riverstone Subdivision Yoursection Ltd		Scale @ A3 NTS
Job reference Drawing number 20082 ST LT-001	Revision AO	Purpose of Issue Approval




xteriorscapes
LANDSCAPE ARCHITECTS

 441 Papanui Road, PO Box 36-511
Christchurch 8146

 m: 021 433 418 t: 03 421 8460
hayden@xteriorscapes.nz
www.xteriorscapes.nz

- Key:
-  Proposed Tree
 -  Garden Bed
 -  Grass
 -  Proposed Lot
 -  Street light

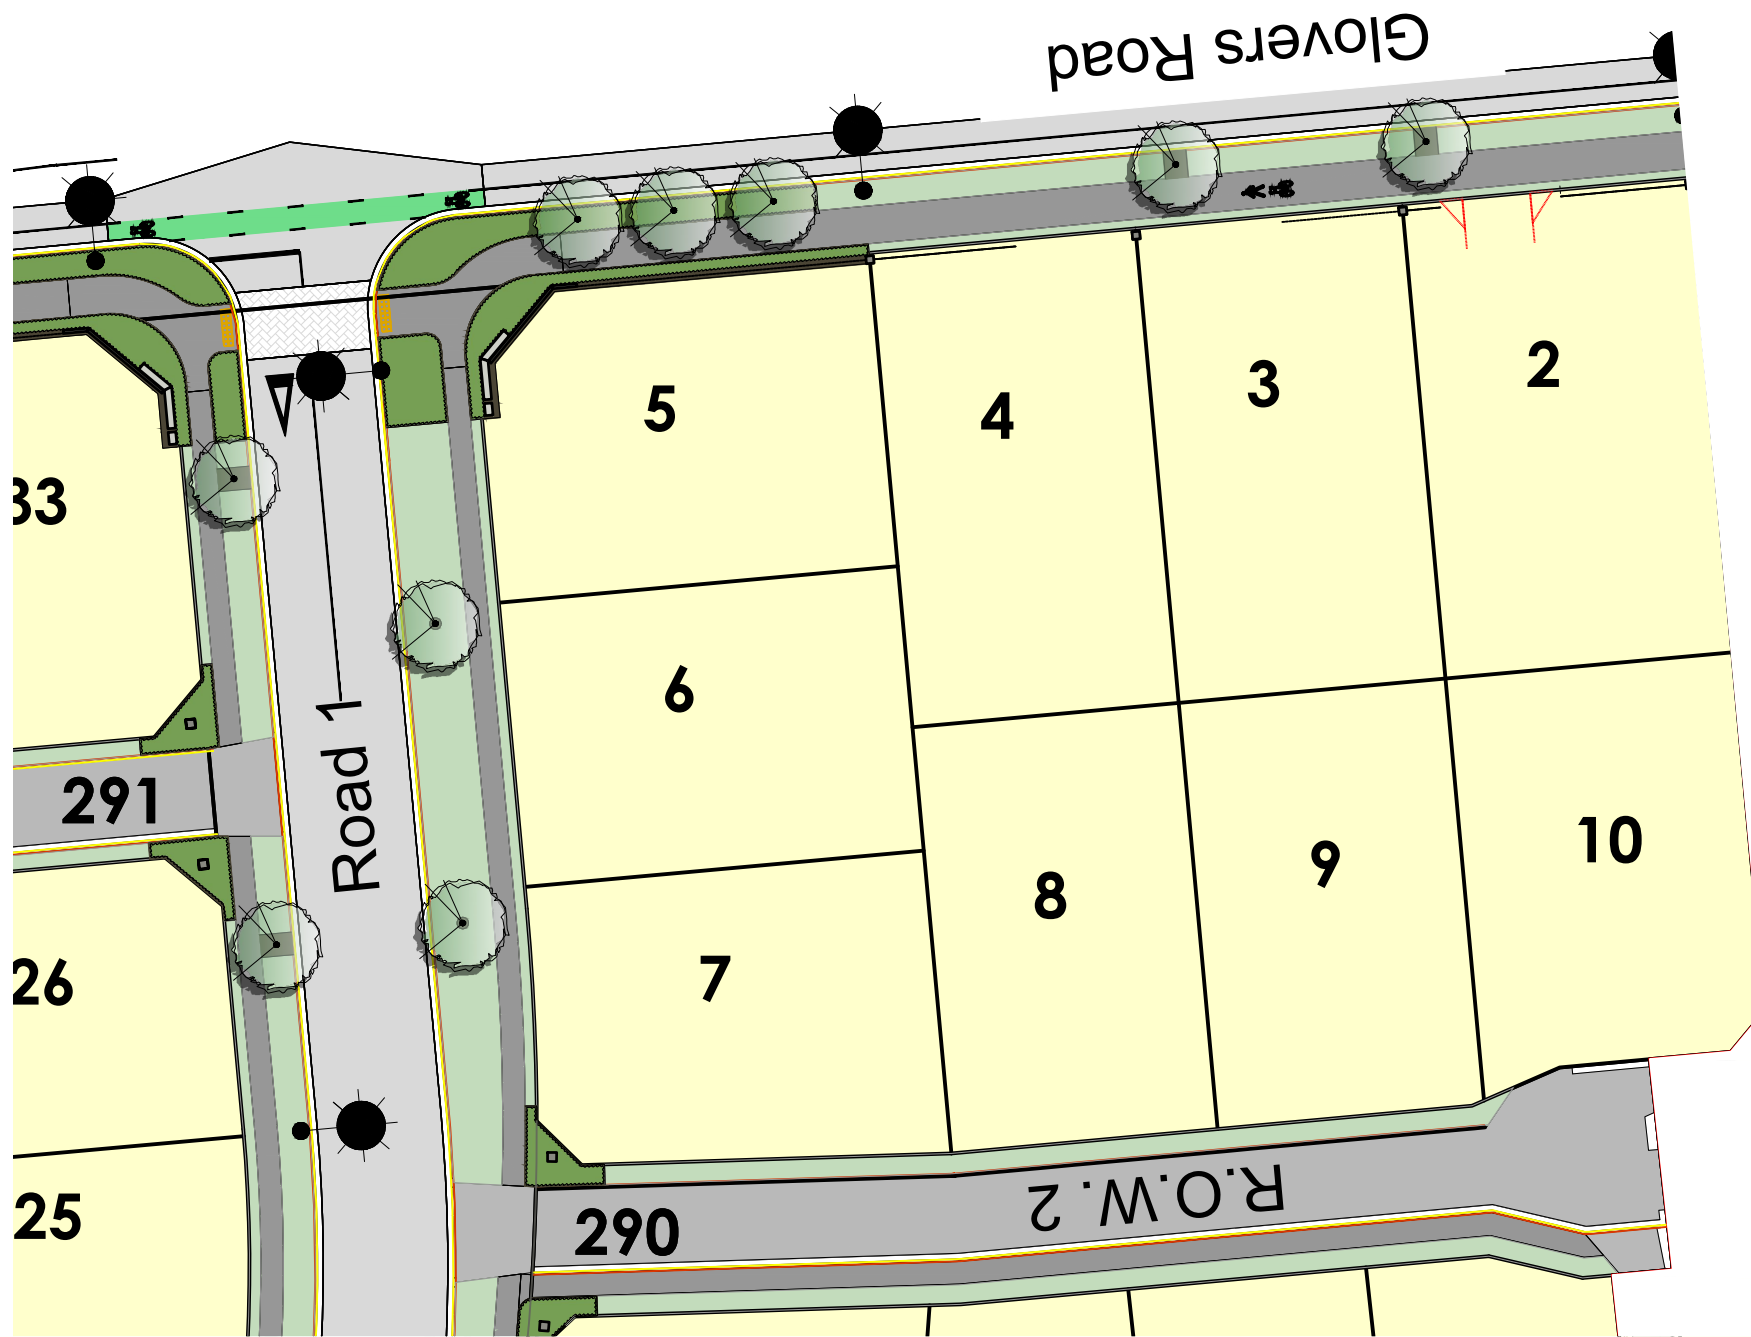



PLEASE NOTE

FOR CONSTRUCTION PURPOSES USE ONLY FIGURED DIMENSIONS. THIS DRAWING MUST ALWAYS BE READ IN CONJUNCTION WITH ALL RELEVANT PROJECT DETAILS. ALL DIMENSIONS MUST BE CHECKED ON SITE PRIOR TO COMMENCEMENT. PLEASE REPORT ANY DISCREPANCY TO THE ARCHITECT OR CONTRACT ADMINISTRATOR

© COPYRIGHT XTERIORSCAPES 2022

Revisions
AO 26/10/22 Initial Design

 1:500

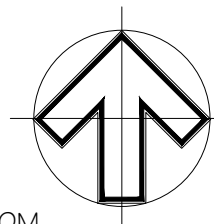

Drawing
Street Tree and Lighting Plan
Project/Client
Riverstone Subdivision
Yoursection Ltd

Job reference | Drawing number
20082 ST LT-002

Revision
AO

Project Date
Jun 2021

Scale @ A3
1:500

 

 
 

Purpose of Issue
Approval




441 Papanui Road, PO Box 36-511
Christchurch 8146

m: 021 433 418 t: 03 421 8460
hayden@xteriorscapes.nz
www.xteriorscapes.nz

Key:

-  Proposed Tree
-  Garden Bed
-  Grass
-  Proposed Lot
-  Street light

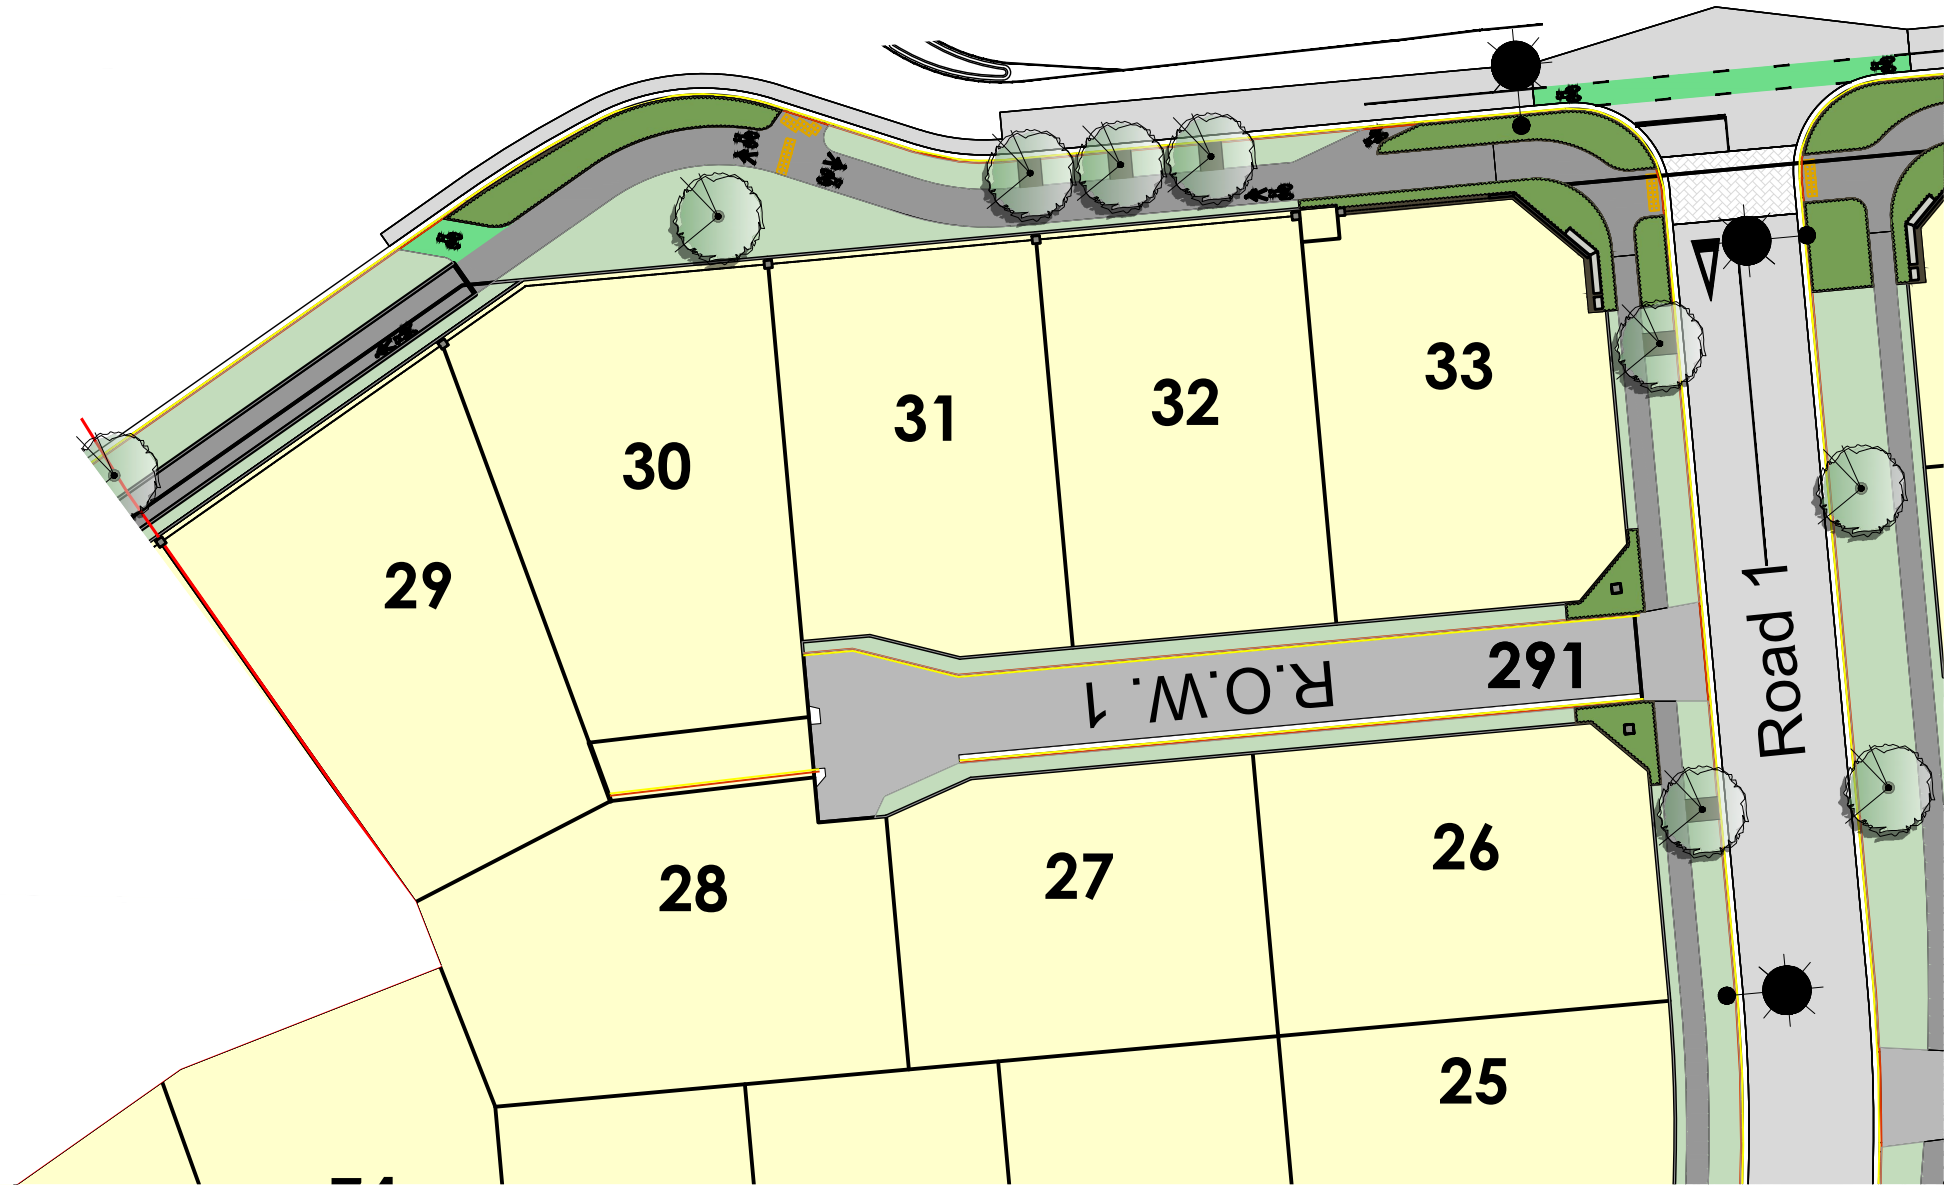



PLEASE NOTE

FOR CONSTRUCTION PURPOSES USE ONLY FIGURED DIMENSIONS. THIS DRAWING MUST ALWAYS BE READ IN CONJUNCTION WITH ALL RELEVANT PROJECT DETAILS. ALL DIMENSIONS MUST BE CHECKED ON SITE PRIOR TO COMMENCEMENT. PLEASE REPORT ANY DISCREPANCY TO THE ARCHITECT OR CONTRACT ADMINISTRATOR

© COPYRIGHT XTERIORSCAPES 2022

Revisions
AO 26/10/22 Initial Design

 1:500

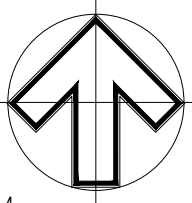Drawing Street Tree and Lighting Plan		Project Date Jun 2021	
Project/Client Riverstone Subdivision Yoursection Ltd		Scale @ A3 1:500	
Job reference Drawing number 20082 ST LT-003		Revision AO	Purpose of Issue Approval



xteriorscapes
LANDSCAPE ARCHITECTS

441 Papanui Road, PO Box 36-511
Christchurch 8146

m: 021 433 418 t: 03 421 8460
hayden@xteriorscapes.nz
www.xteriorscapes.nz



- Key:
- Proposed Tree
 - Garden Bed
 - Grass
 - Proposed Lot
 - Street light


PLEASE NOTE

FOR CONSTRUCTION PURPOSES USE ONLY FIGURED DIMENSIONS. THIS DRAWING MUST ALWAYS BE READ IN CONJUNCTION WITH ALL RELEVANT PROJECT DETAILS. ALL DIMENSIONS MUST BE CHECKED ON SITE PRIOR TO COMMENCEMENT. PLEASE REPORT ANY DISCREPANCY TO THE ARCHITECT OR CONTRACT ADMINISTRATOR

© COPYRIGHT XTERIORSCAPES 2022

Revisions
AO 26/10/22 Initial Design

1:500

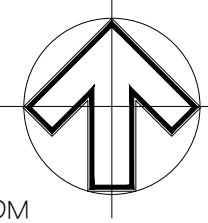

Drawing
Street Tree and Lighting Plan
Project/Client
Riverstone Subdivision
Yoursection Ltd

Job reference | Drawing number
20082 ST LT-004

Revision
AO

Project Date
Jun 2021


 
 
 

Scale @ A3
1:500


Purpose of Issue
Approval



441 Papanui Road, PO Box 36-511
Christchurch 8146

m: 021 433 418 t: 03 421 8460
hayden@xteriorscapes.nz
www.xteriorscapes.nz



- Key:
-  Proposed Tree
 -  Garden Bed
 -  Grass
 -  Proposed Lot
 -  Street light

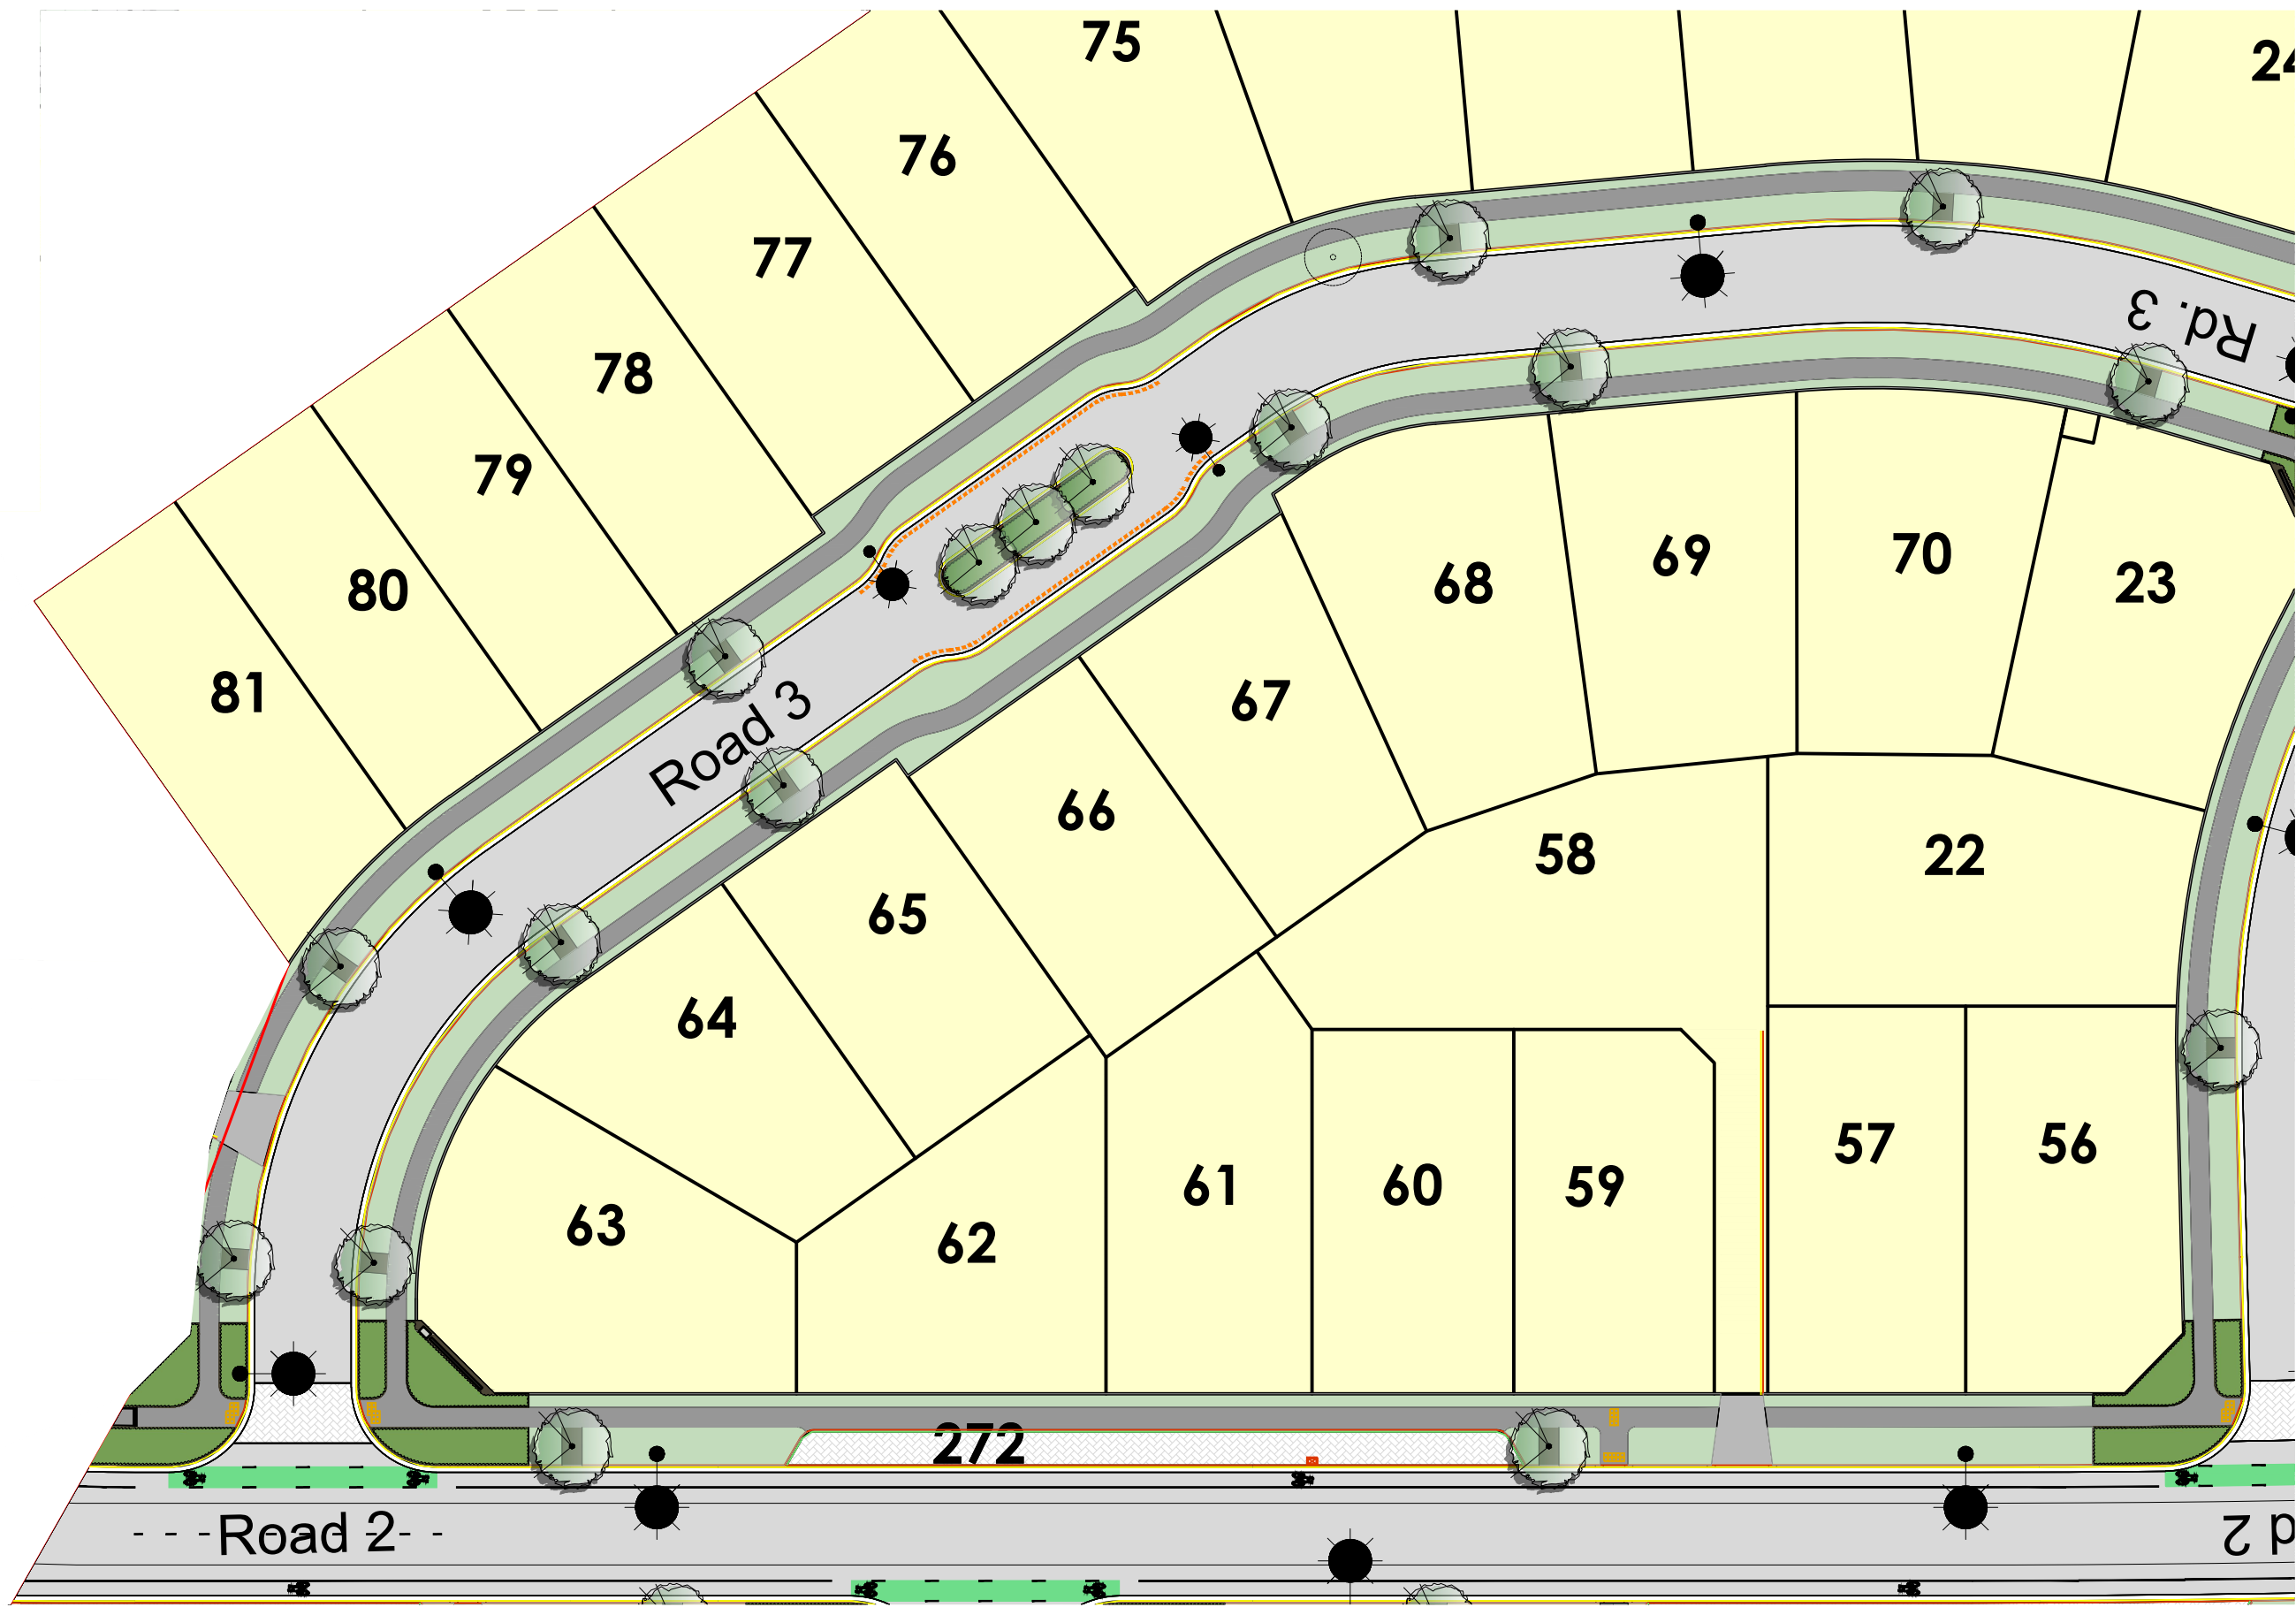

PLEASE NOTE

FOR CONSTRUCTION PURPOSES USE ONLY FIGURED DIMENSIONS. THIS DRAWING MUST ALWAYS BE READ IN CONJUNCTION WITH ALL RELEVANT PROJECT DETAILS. ALL DIMENSIONS MUST BE CHECKED ON SITE PRIOR TO COMMENCEMENT. PLEASE REPORT ANY DISCREPANCY TO THE ARCHITECT OR CONTRACT ADMINISTRATOR

© COPYRIGHT XTERIORSCAPES 2022

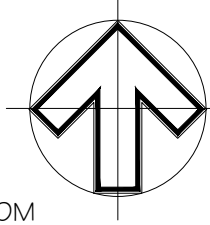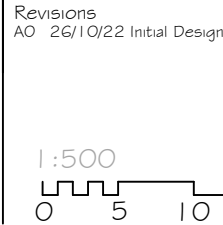


Drawing		Project Date
Street Tree and Lighting Plan		Jun 2021
Project/Client		Scale @ A3
Riverstone Subdivision		1:500
Yoursection Ltd		Purpose of Issue
Job reference Drawing number		Approval
20082 ST LT-005		
Revision		
AO		



xteriorscapes
LANDSCAPE ARCHITECTS

441 Papanui Road, PO Box 36-511
Christchurch 8146

m: 021 433 418 t: 03 421 8460
hayden@xteriorscapes.nz
www.xteriorscapes.nz


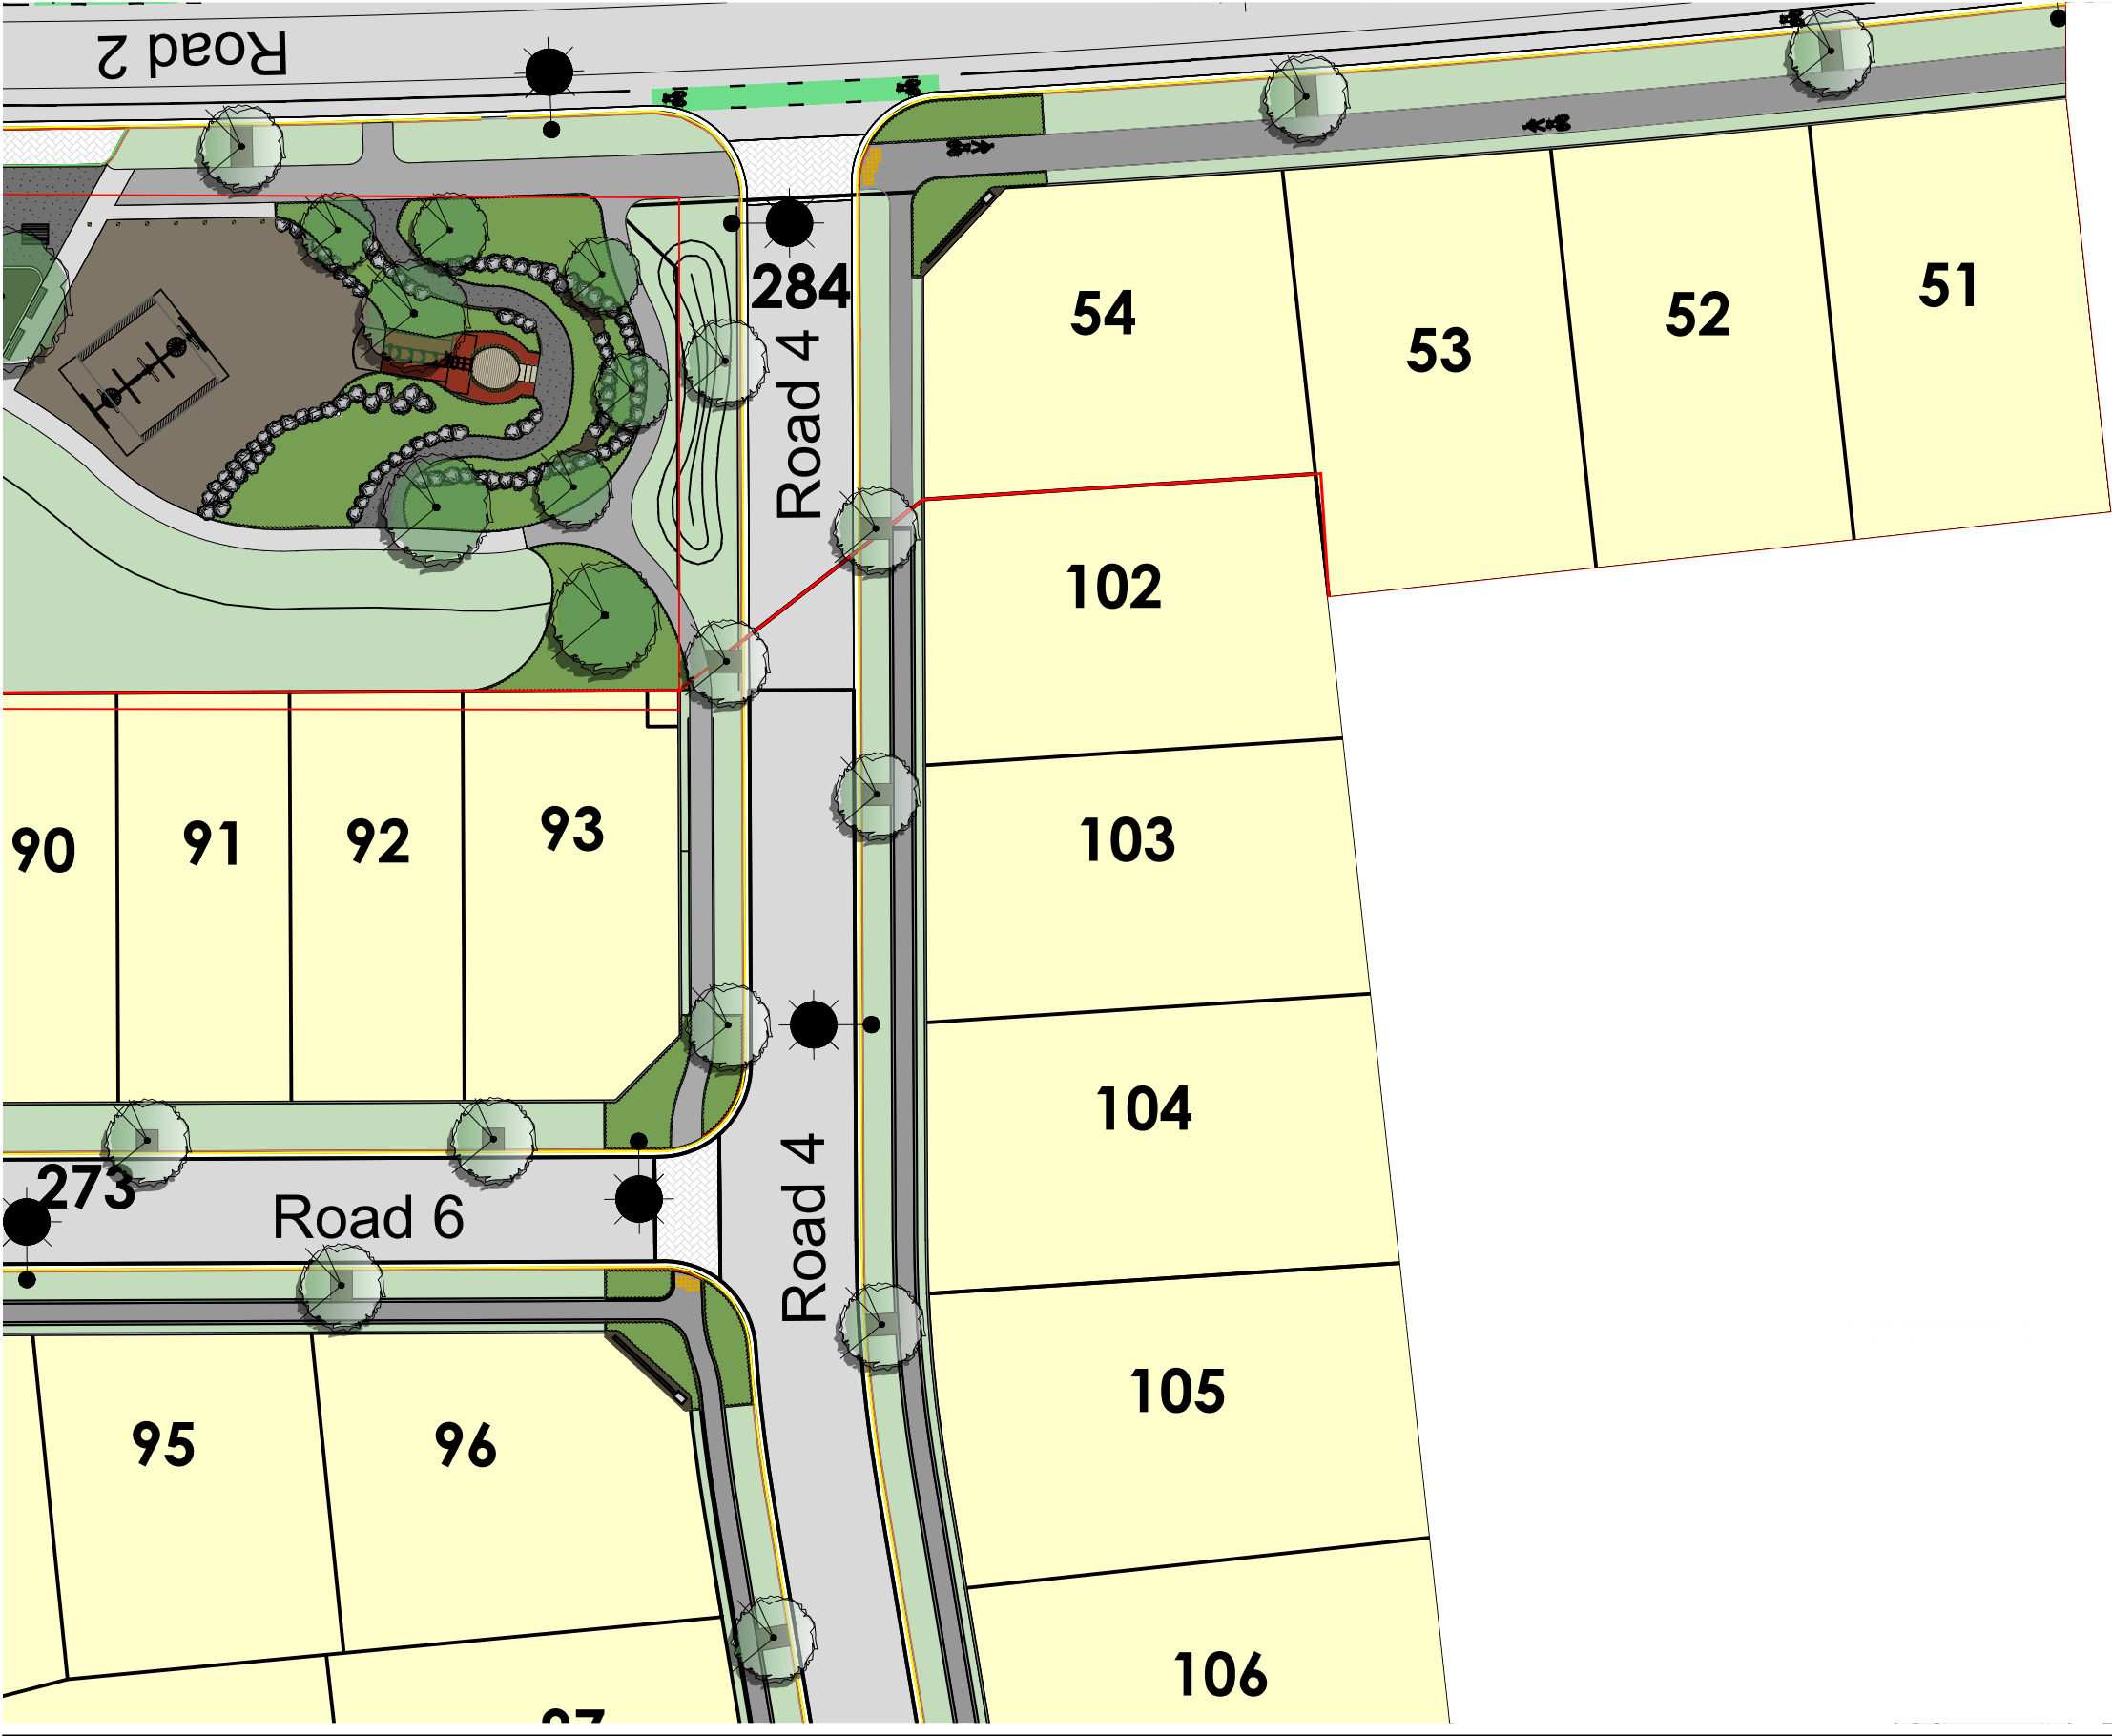


- Key:
- Proposed Tree
 - Garden Bed
 - Grass
 - Proposed Lot
 - Street light

PLEASE NOTE

FOR CONSTRUCTION PURPOSES USE ONLY FIGURED DIMENSIONS. THIS DRAWING MUST ALWAYS BE READ IN CONJUNCTION WITH ALL RELEVANT PROJECT DETAILS. ALL DIMENSIONS MUST BE CHECKED ON SITE PRIOR TO COMMENCEMENT. PLEASE REPORT ANY DISCREPANCY TO THE ARCHITECT OR CONTRACT ADMINISTRATOR

© COPYRIGHT XTERIORSCAPES 2022

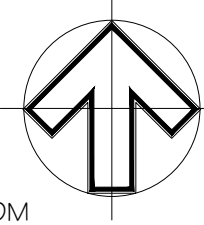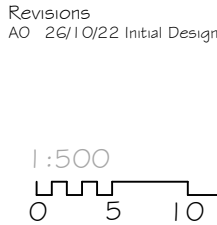


Drawing Street Tree and Lighting Plan		Project Date Jun 2021	
Project/Client Riverstone Subdivision Yoursection Ltd		Scale @ A3 1:500	
Job reference Drawing number 20082 ST LT-006		Revision AO	Purpose of Issue Approval

xteriorscapes
LANDSCAPE ARCHITECTS

441 Papanui Road, PO Box 36-511
Christchurch 8146

m: 021 433 418 t: 03 421 8460
hayden@xteriorscapes.nz
www.xteriorscapes.nz

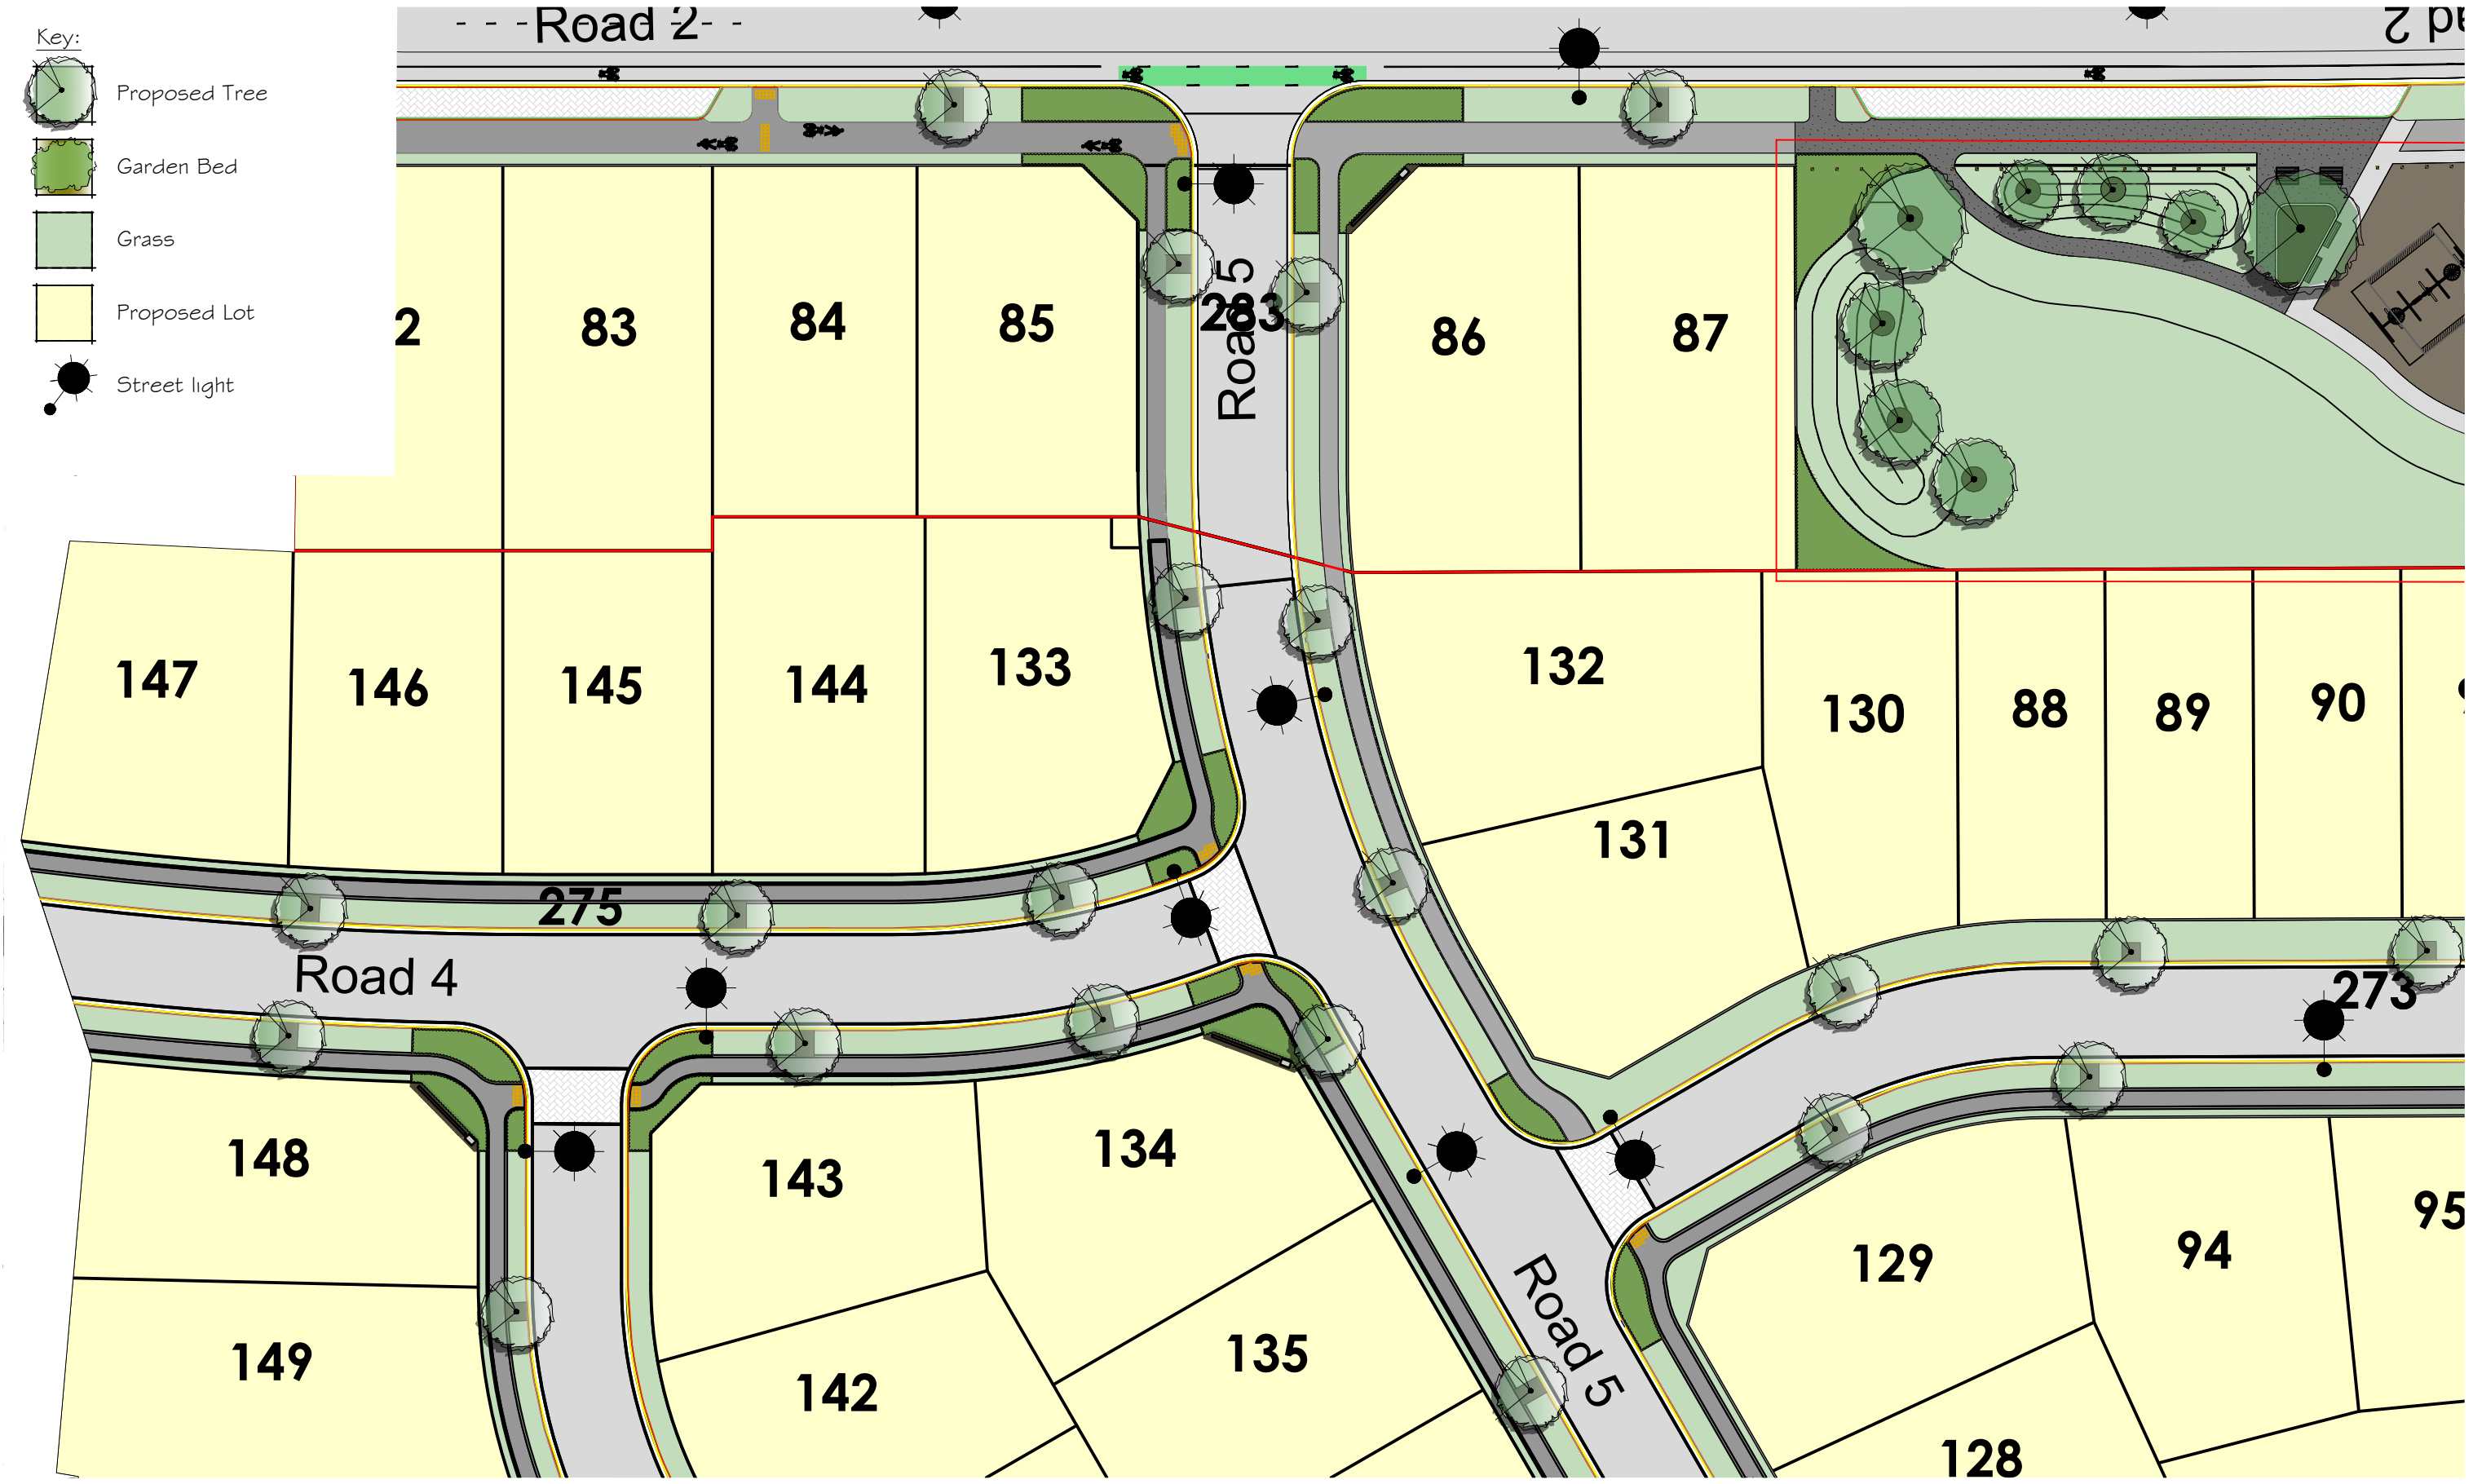

Key:

- Proposed Tree
- Garden Bed
- Grass
- Proposed Lot
- Street light

PLEASE NOTE

FOR CONSTRUCTION PURPOSES USE ONLY FIGURED DIMENSIONS. THIS DRAWING MUST ALWAYS BE READ IN CONJUNCTION WITH ALL RELEVANT PROJECT DETAILS. ALL DIMENSIONS MUST BE CHECKED ON SITE PRIOR TO COMMENCEMENT. PLEASE REPORT ANY DISCREPANCY TO THE ARCHITECT OR CONTRACT ADMINISTRATOR


© COPYRIGHT XTERIORSCAPES 2022

Revisions

AO 26/10/22 Initial Design

1:500

0 5 10 20 30 40 50M

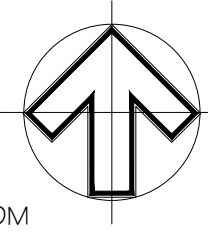


Drawing Street Tree and Lighting Plan		Project Date Jun 2021
Project/Client Riverstone Subdivision Yoursection Ltd		Scale @ A3 1:500
Job reference Drawing number 20082 ST LT-007	Revision AO	Purpose of Issue Approval

xteriorscapes
LANDSCAPE ARCHITECTS

441 Papanui Road, PO Box 36-511
Christchurch 8146

m: 021 433 418 t: 03 421 8460
hayden@xteriorscapes.nz
www.xteriorscapes.nz

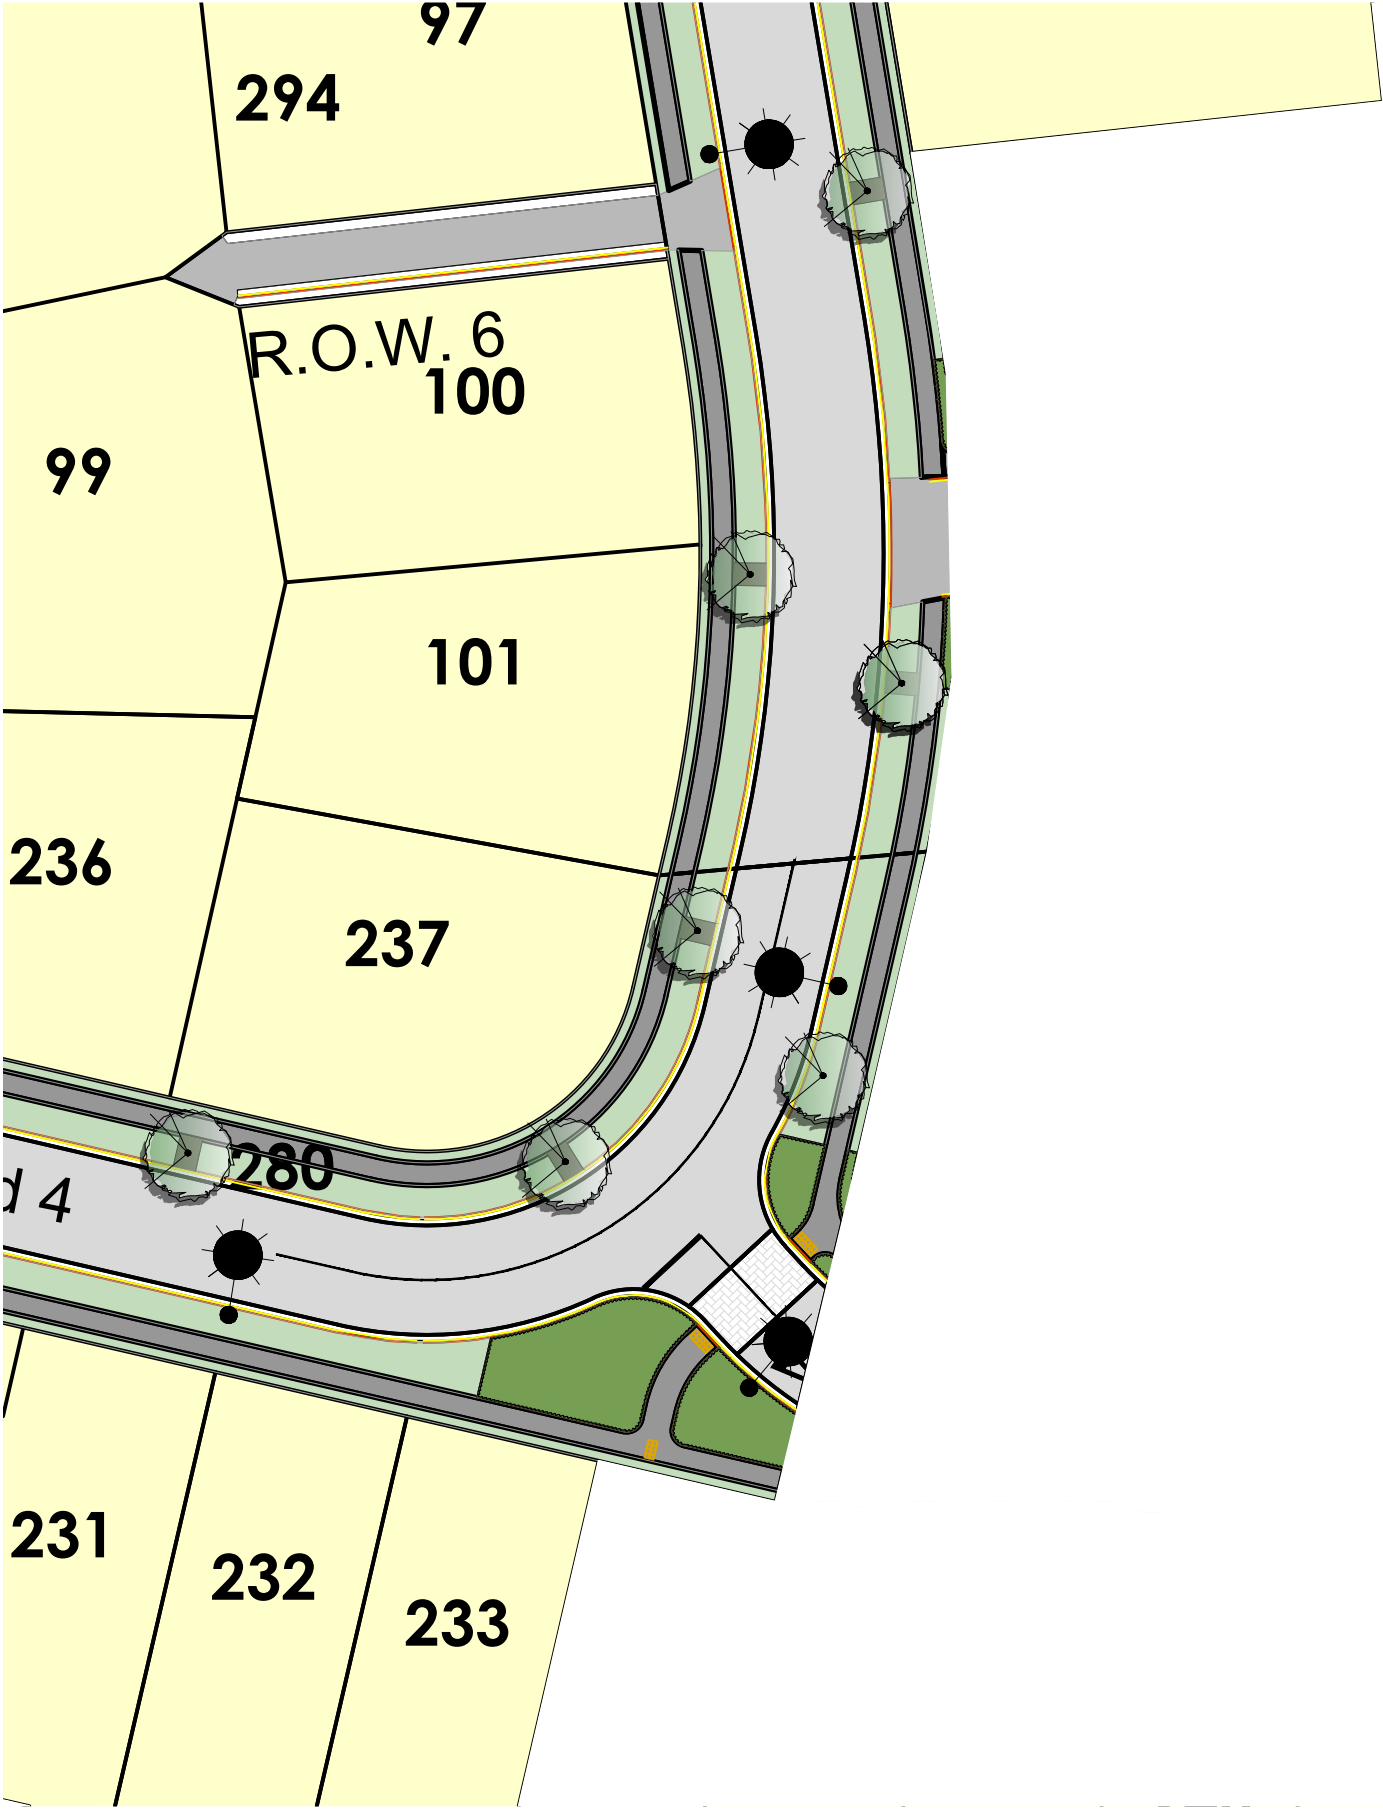

Key:

-  Proposed Tree
-  Garden Bed
-  Grass
-  Proposed Lot
-  Street light


PLEASE NOTE

FOR CONSTRUCTION PURPOSES USE ONLY FIGURED DIMENSIONS. THIS DRAWING MUST ALWAYS BE READ IN CONJUNCTION WITH ALL RELEVANT PROJECT DETAILS. ALL DIMENSIONS MUST BE CHECKED ON SITE PRIOR TO COMMENCEMENT. PLEASE REPORT ANY DISCREPANCY TO THE ARCHITECT OR CONTRACT ADMINISTRATOR

© COPYRIGHT XTERIORSCAPES 2022

Revisions
AO 26/10/22 Initial Design

1:500

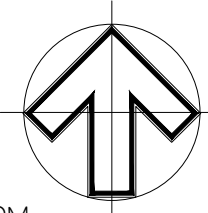

Drawing Street Tree and Lighting Plan		Project Date Jun 2021	
Project/Client Riverstone Subdivision Yoursection Ltd		Scale @ A3 1:500	
Job reference Drawing number 20082 ST LT-008		Revision AO	Purpose of Issue Approval



xteriorscapes
LANDSCAPE ARCHITECTS

441 Papanui Road, PO Box 36-511
Christchurch 8146

m: 021 433 418 t: 03 421 8460
hayden@xteriorscapes.nz
www.xteriorscapes.nz



PLEASE NOTE


FOR CONSTRUCTION PURPOSES USE ONLY FIGURED DIMENSIONS. THIS DRAWING MUST ALWAYS BE READ IN CONJUNCTION WITH ALL RELEVANT PROJECT DETAILS. ALL DIMENSIONS MUST BE CHECKED ON SITE PRIOR TO COMMENCEMENT. PLEASE REPORT ANY DISCREPANCY TO THE ARCHITECT OR CONTRACT ADMINISTRATOR

© COPYRIGHT XTERIORSCAPES 2022

Revisions
AO 26/10/22 Initial Design

1:500

 
0 5 10 20 30 40 50M

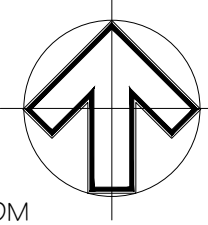


 
Drawing Street Tree and Lighting Plan		Project Date Jun 2021	
Project/Client Riverstone Subdivision Yoursection Ltd		Scale @ A3 1:500	
Job reference Drawing number 20082 ST LT-009		Revision AO	Purpose of Issue Approval


441 Papanui Road, PO Box 36-511
Christchurch 8146
m: 021 433 418 t: 03 421 8460
hayden@xteriorscapes.nz
www.xteriorscapes.nz


Key:



Proposed Tree


Garden Bed

 
Grass


Proposed Lot


Street light


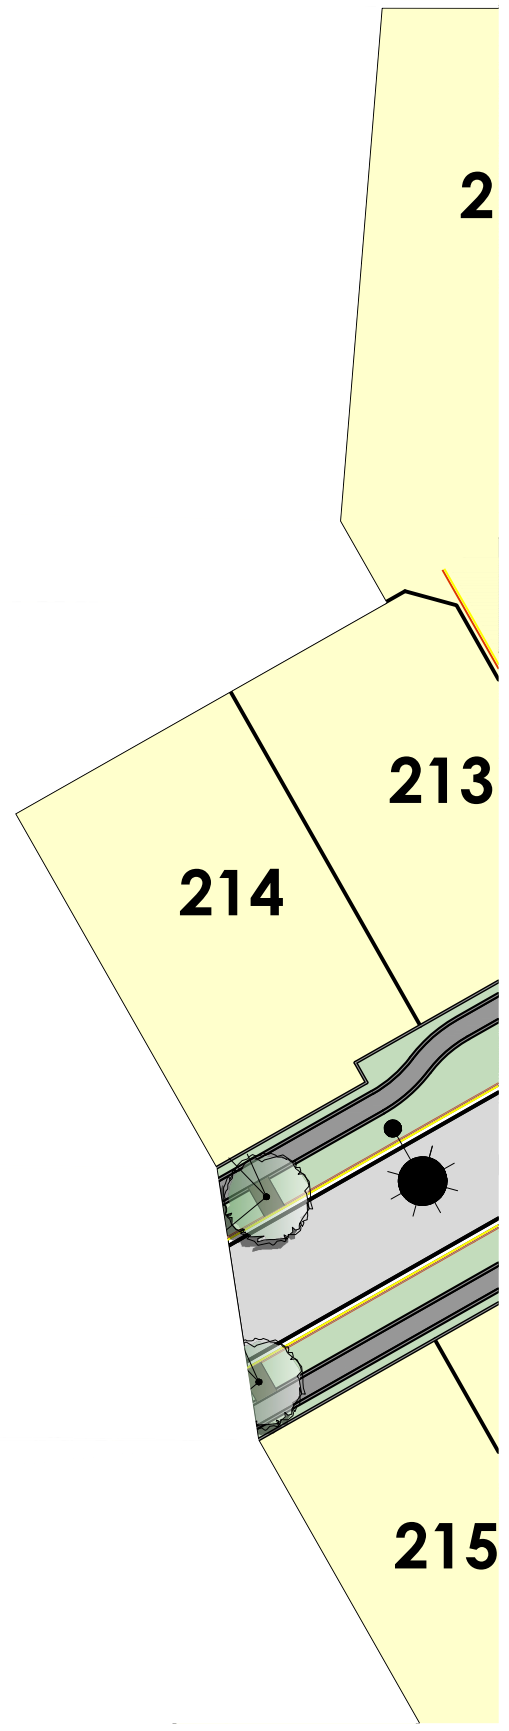


PLEASE NOTE

FOR CONSTRUCTION PURPOSES USE ONLY FIGURED DIMENSIONS. THIS DRAWING MUST ALWAYS BE READ IN CONJUNCTION WITH ALL RELEVANT PROJECT DETAILS. ALL DIMENSIONS MUST BE CHECKED ON SITE PRIOR TO COMMENCEMENT. PLEASE REPORT ANY DISCREPANCY TO THE ARCHITECT OR CONTRACT ADMINISTRATOR

© COPYRIGHT XTERIORSCAPES 2022

 Revisions
AO 26/10/22 Initial Design

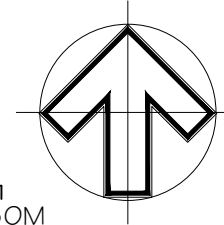

Drawing Street Tree and Lighting Plan		Project Date Jun 2021	
Project/Client Riverstone Subdivision Yoursection Ltd		Scale @ A3 1:500	
Job reference Drawing number 20082 ST LT-010		Revision AO	Purpose of Issue Approval



xteriorscapes
LANDSCAPE ARCHITECTS

441 Papanui Road, PO Box 36-511
Christchurch 8146

m: 021 433 418 t: 03 421 8460
hayden@xteriorscapes.nz
www.xteriorscapes.nz